



2
UPPER GROUND CCTV LAYOUT
SCALE 1:100 M.

EE-6

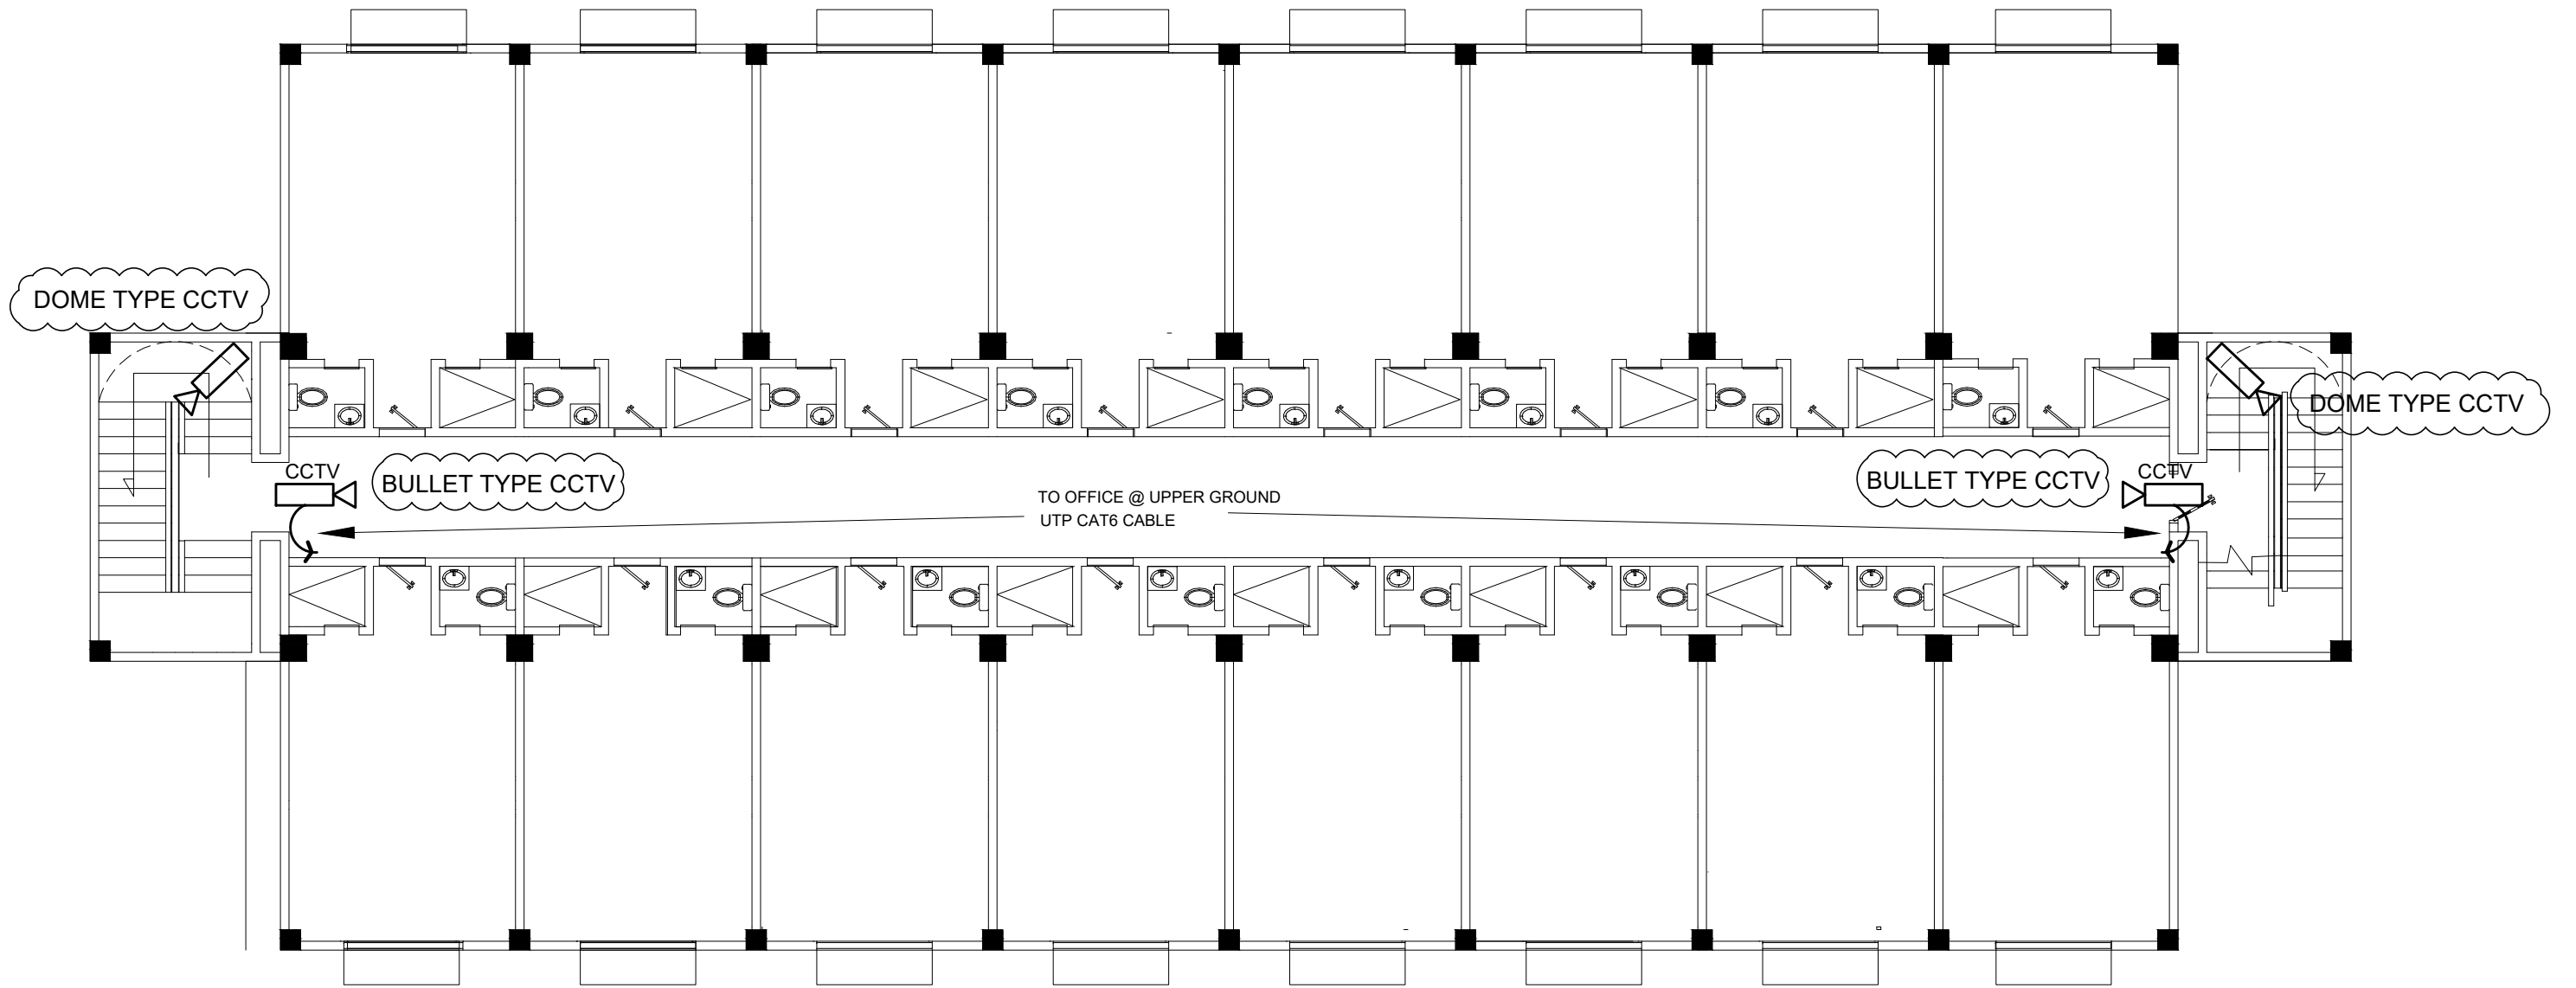


3
EE-6
SECOND FLOOR CCTV LAYOUT
 SCALE 1:100 M.

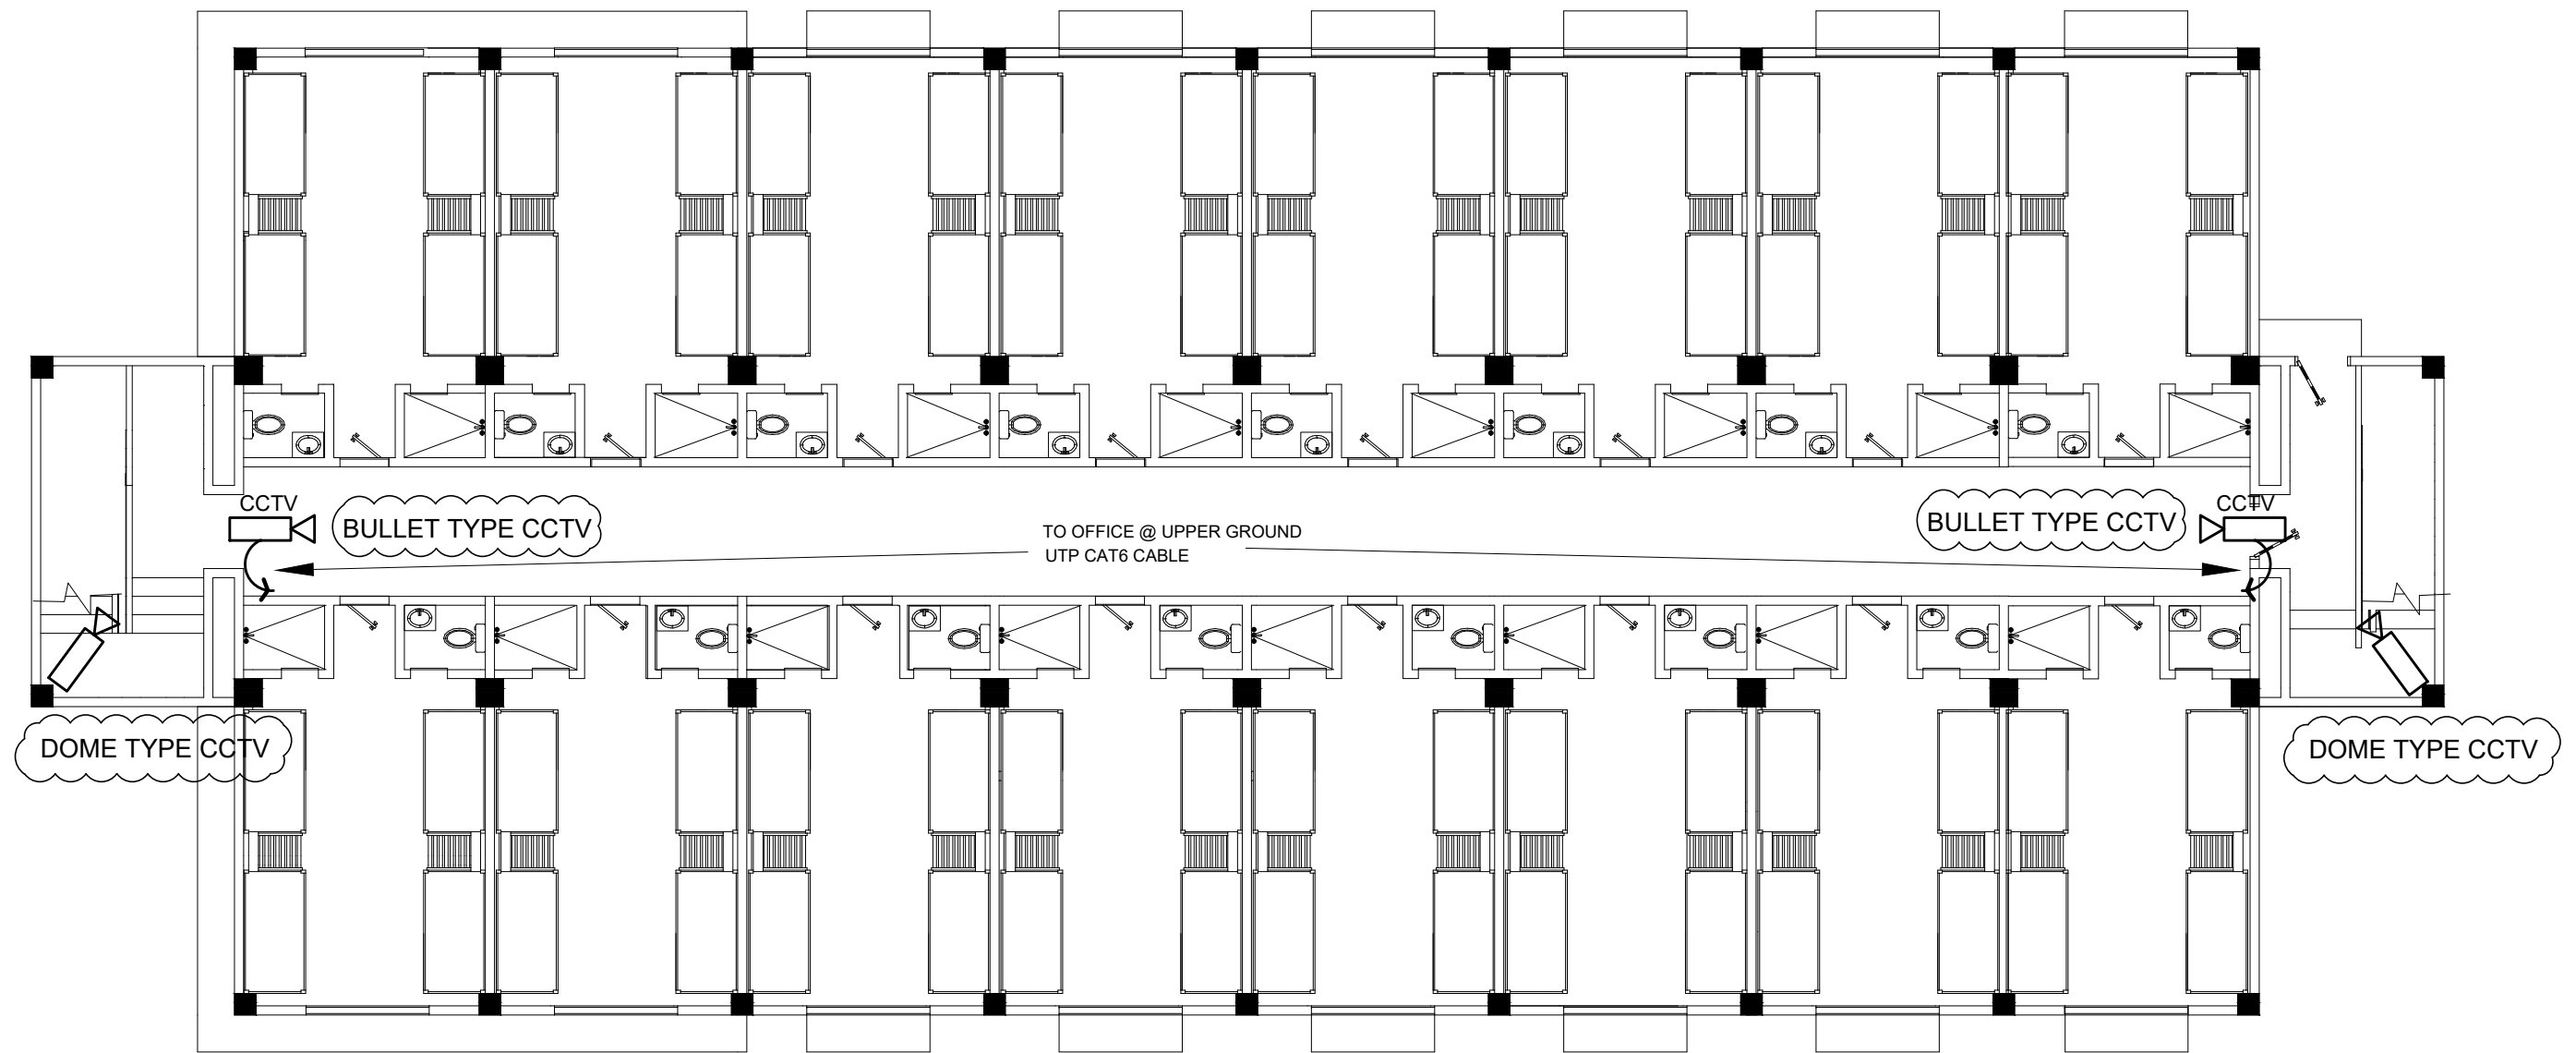


4
EE-6

THIRD FLOOR CCTV LAYOUT
 SCALE 1:100 M.

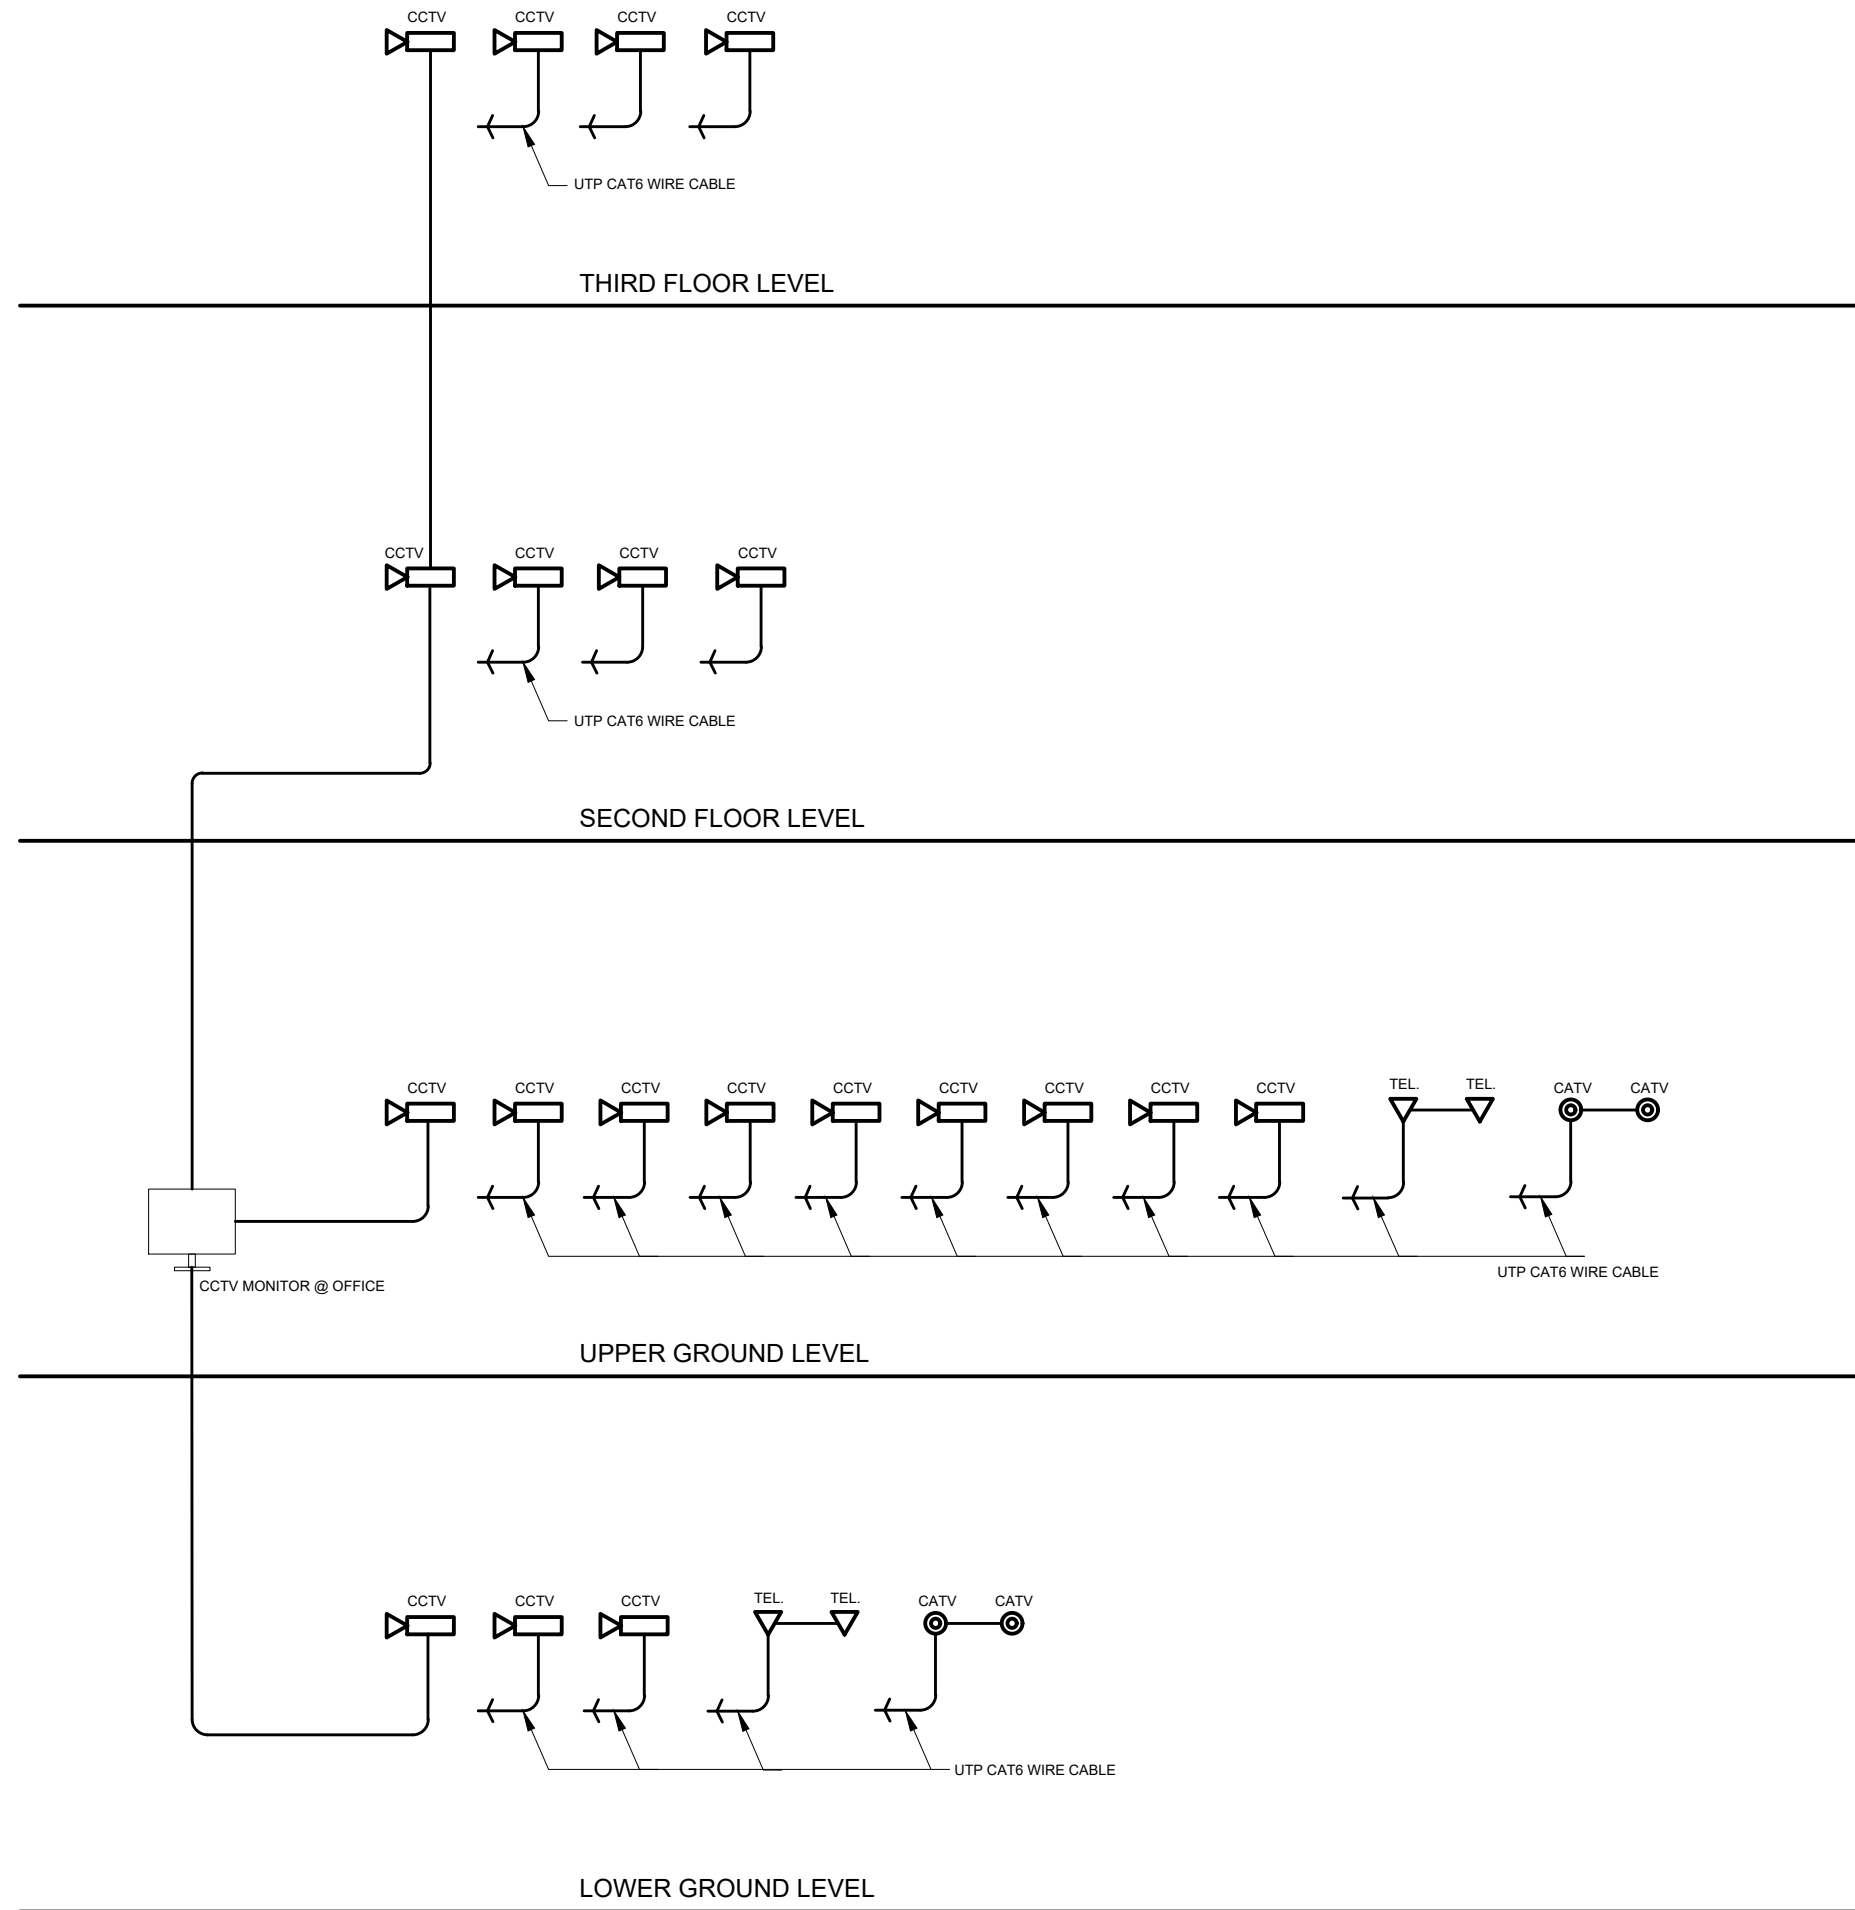

CCTV SINGLE LINE DIAGRAM

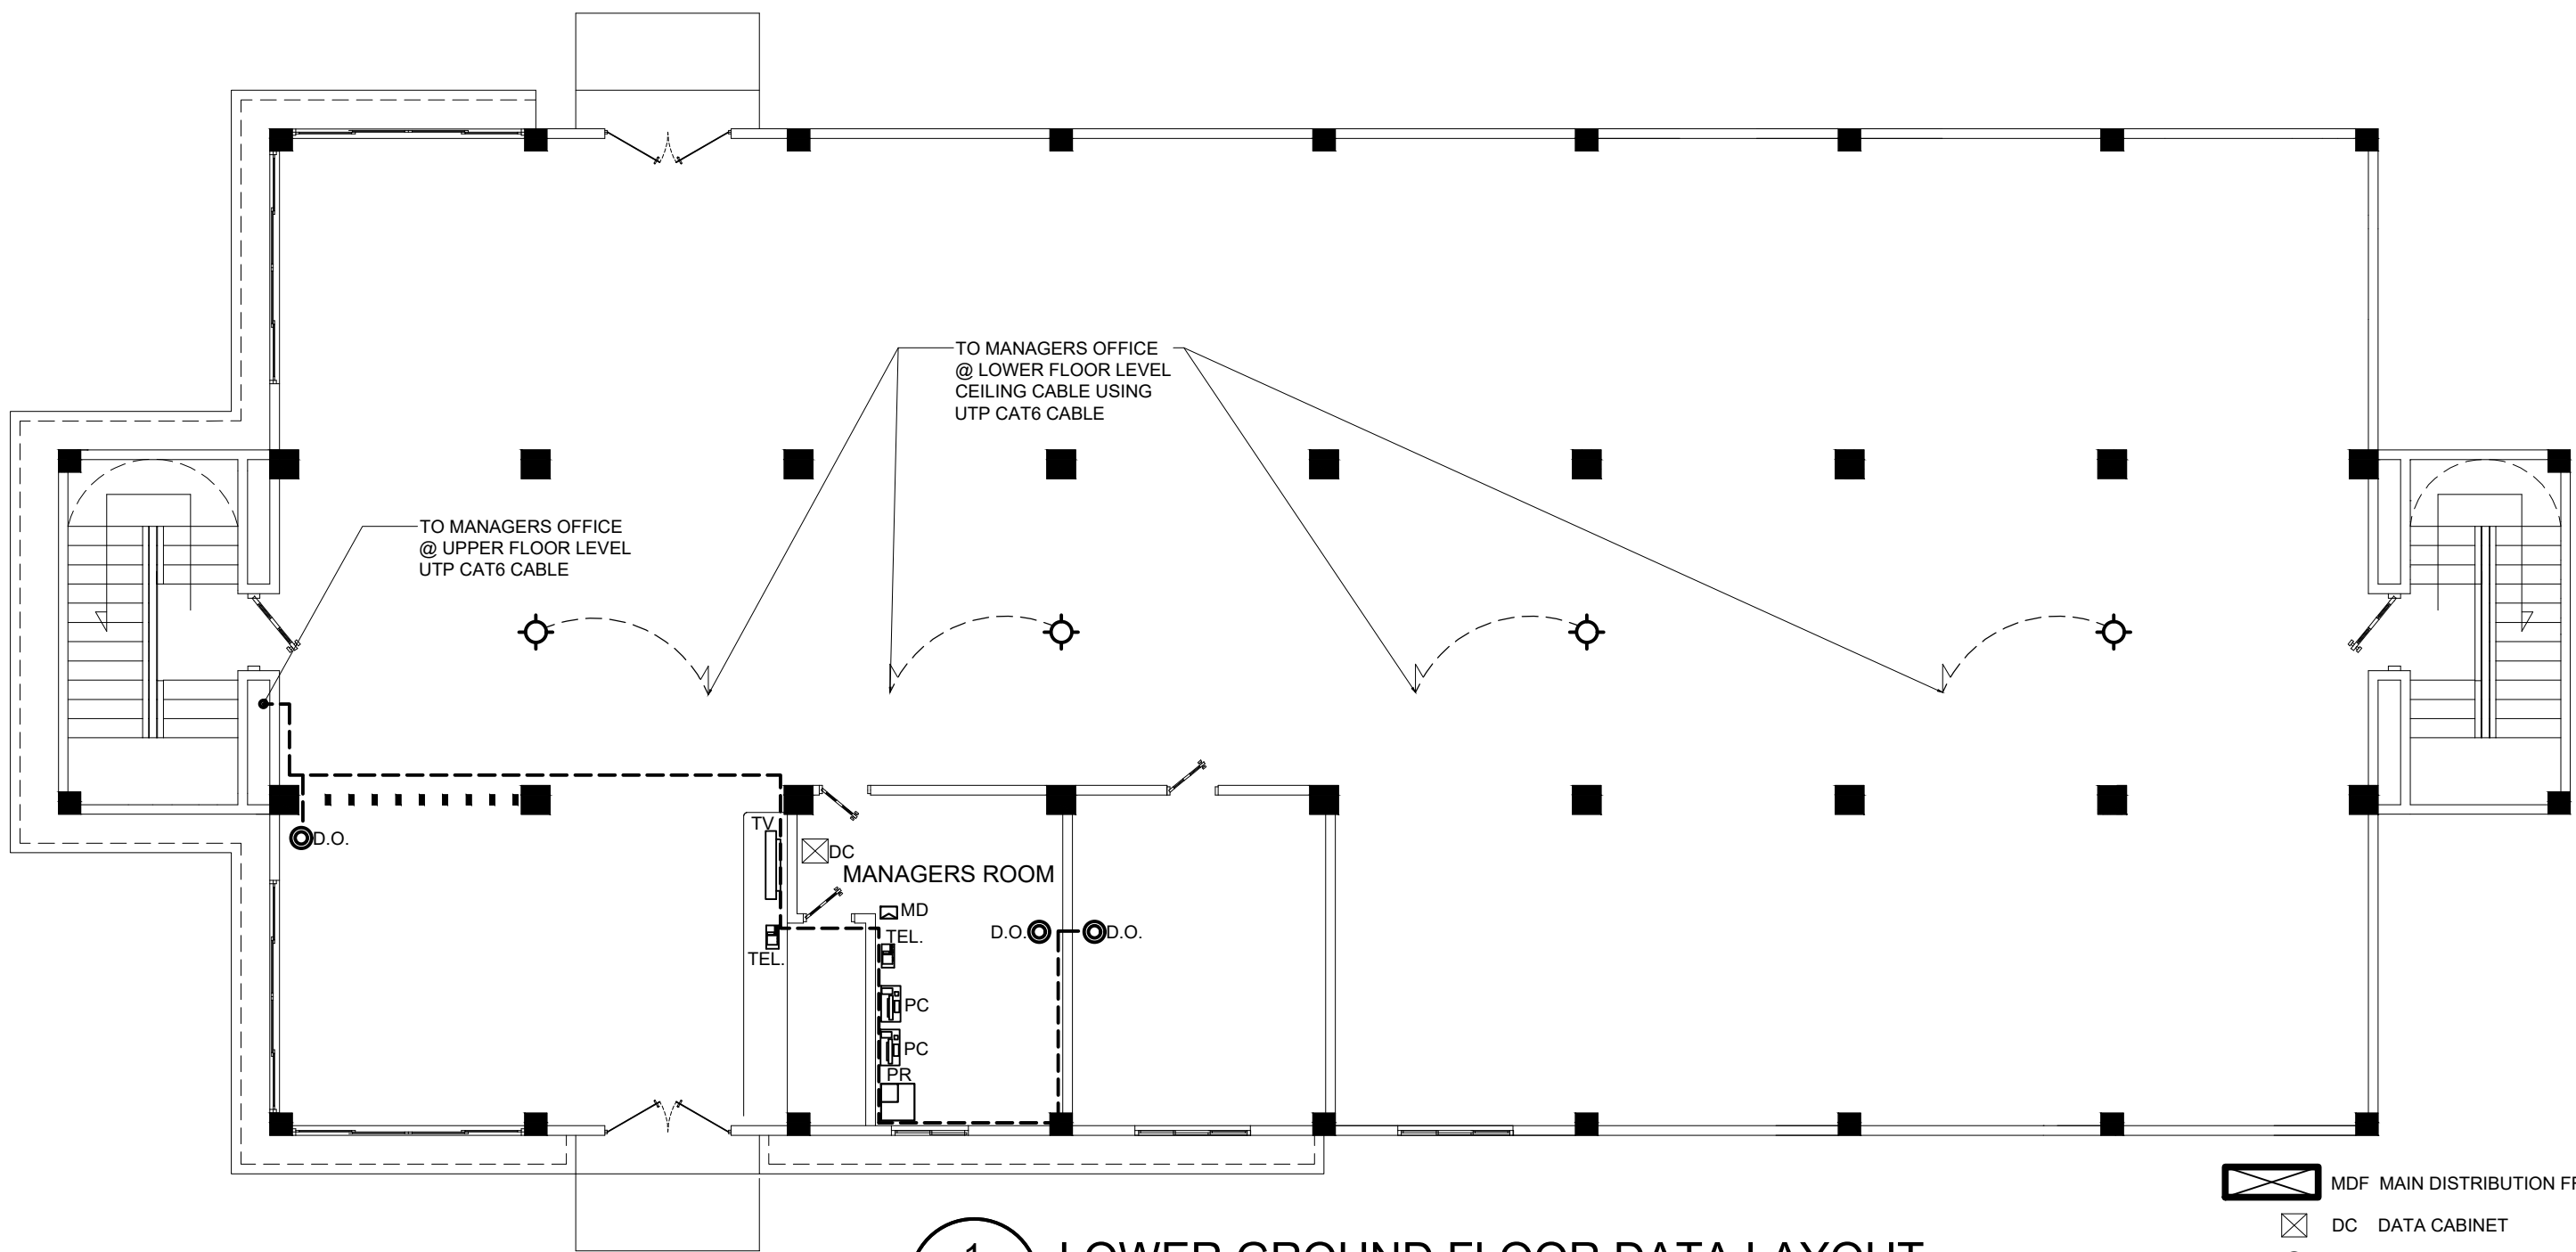


1
EE-6

LOWER GROUND FLOOR DATA LAYOUT
 SCALE 1:100 M.

- MDF MAIN DISTRIBUTION FRAME
- DC DATA CABINET
- D.O. DUPLEX OUTLET
- RT ROUTER
- PR PRINTER
- PC PERSONAL COMPUTER
- MD MODEM
- TV TELEVISION
- ACCESS POINT
- UTP CAT6 CABLE
- CONVENTIONAL SMOKE DETECTOR


D.O. - DATA OUTLET

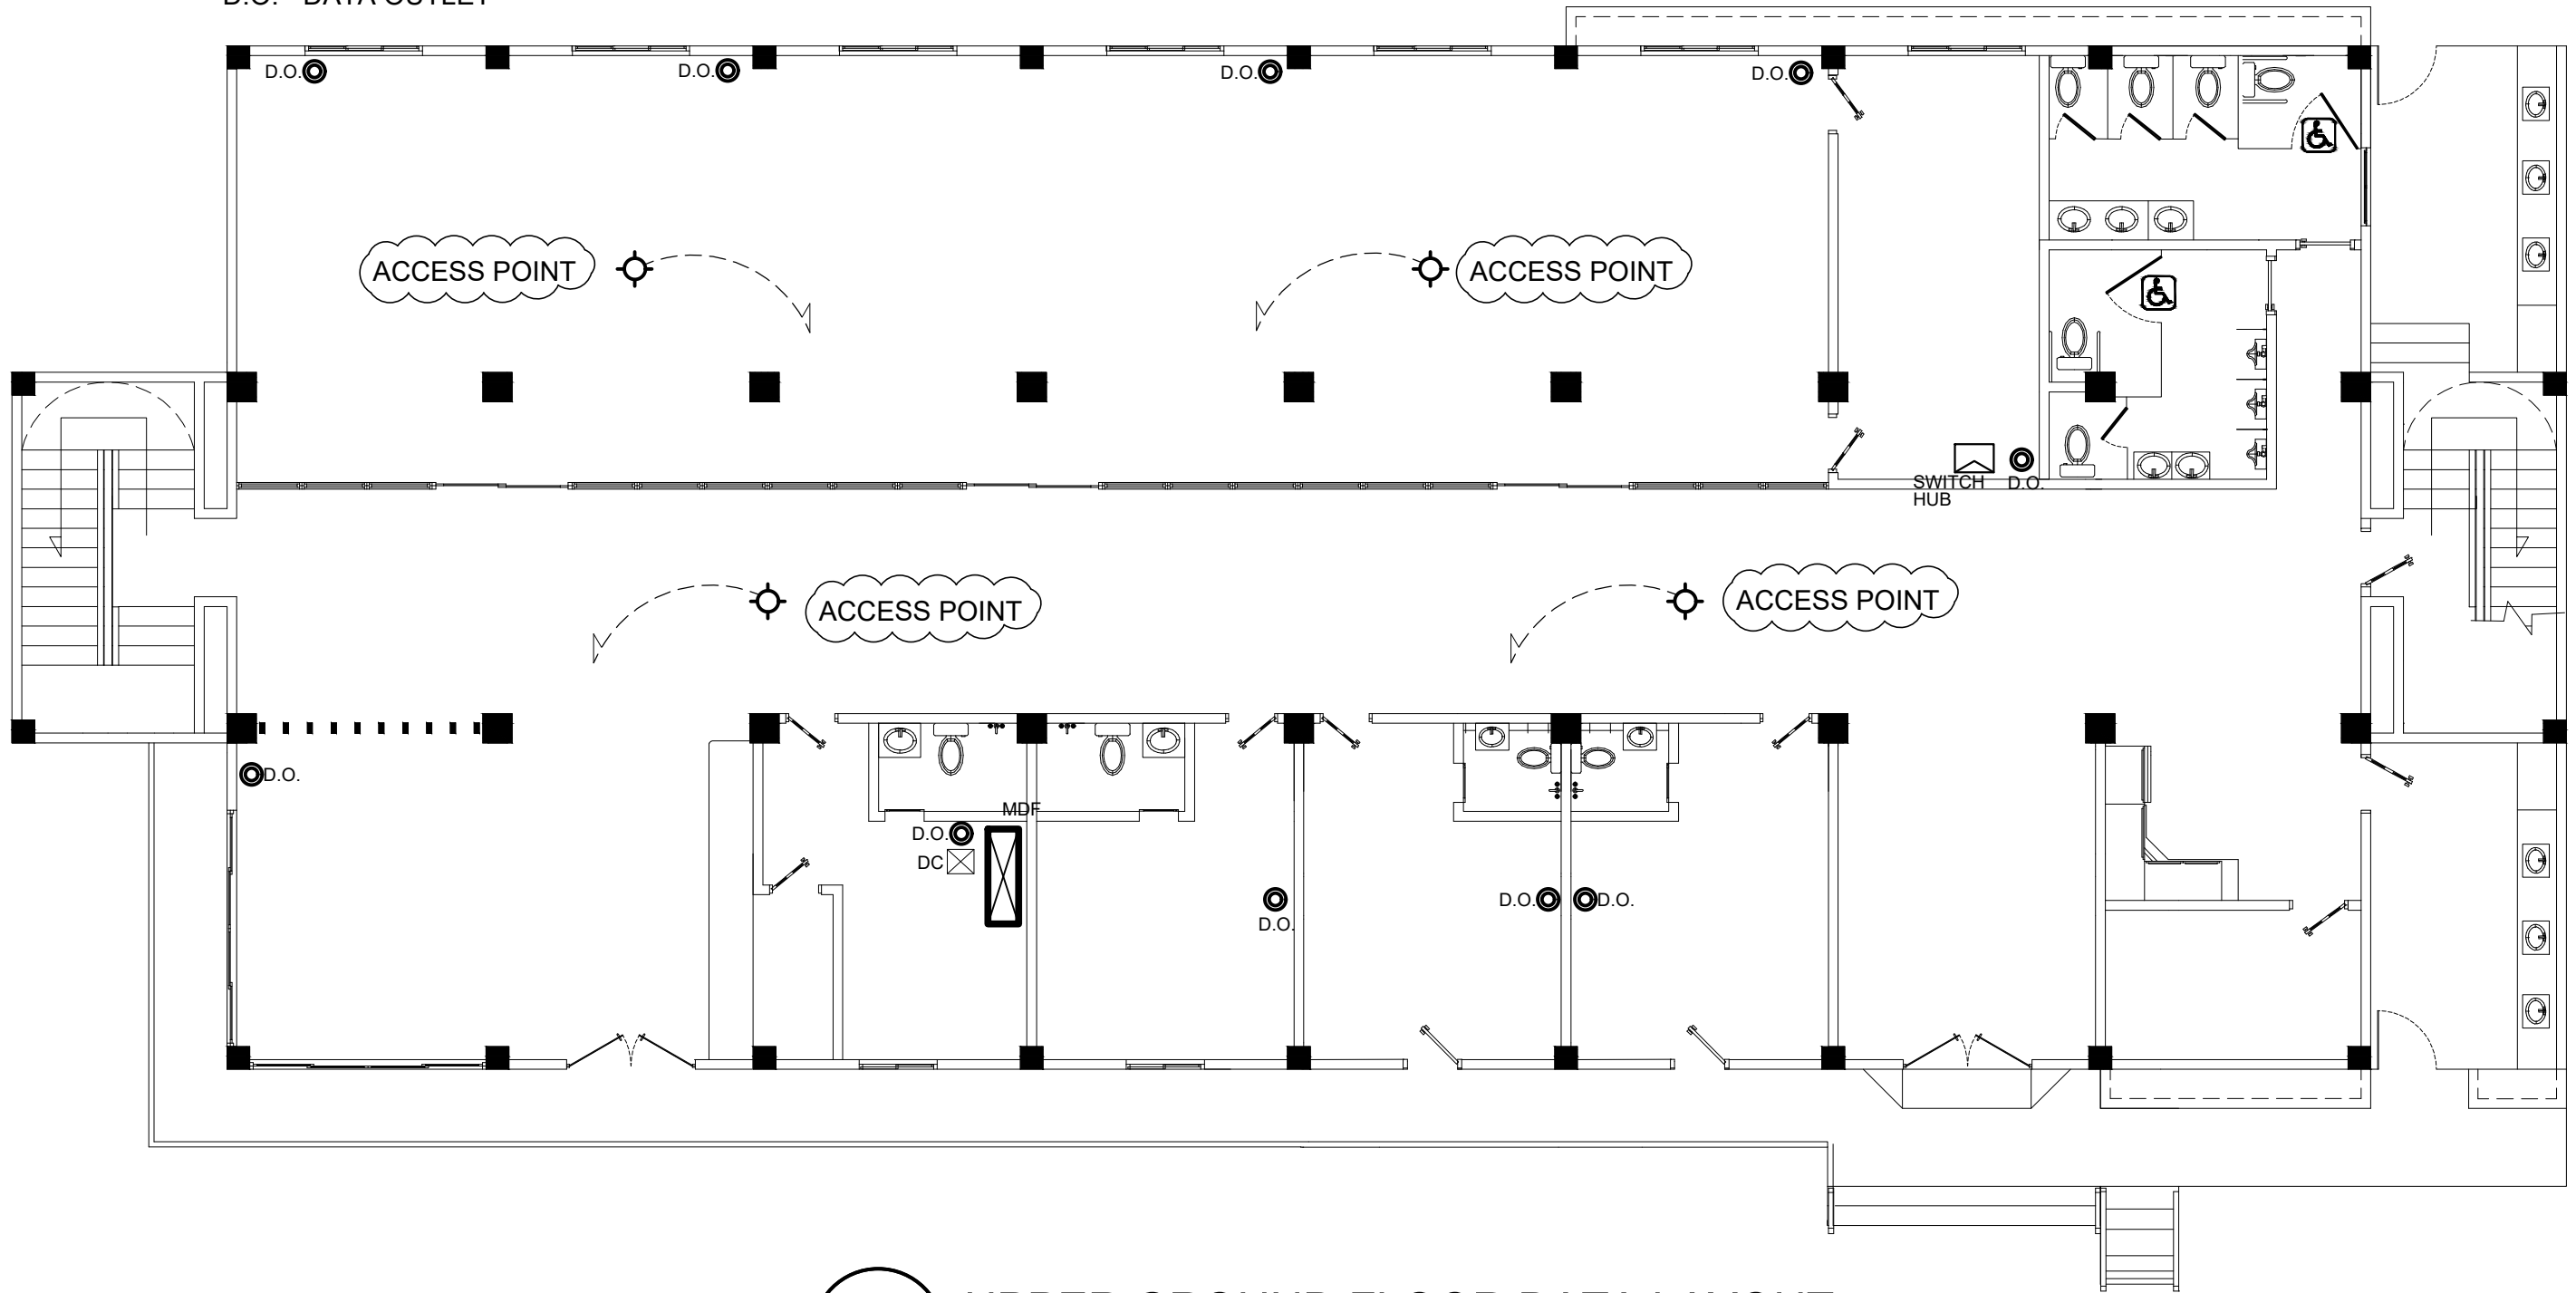

2
EE-6

UPPER GROUND FLOOR DATA LAYOUT

SCALE 1:100 M.

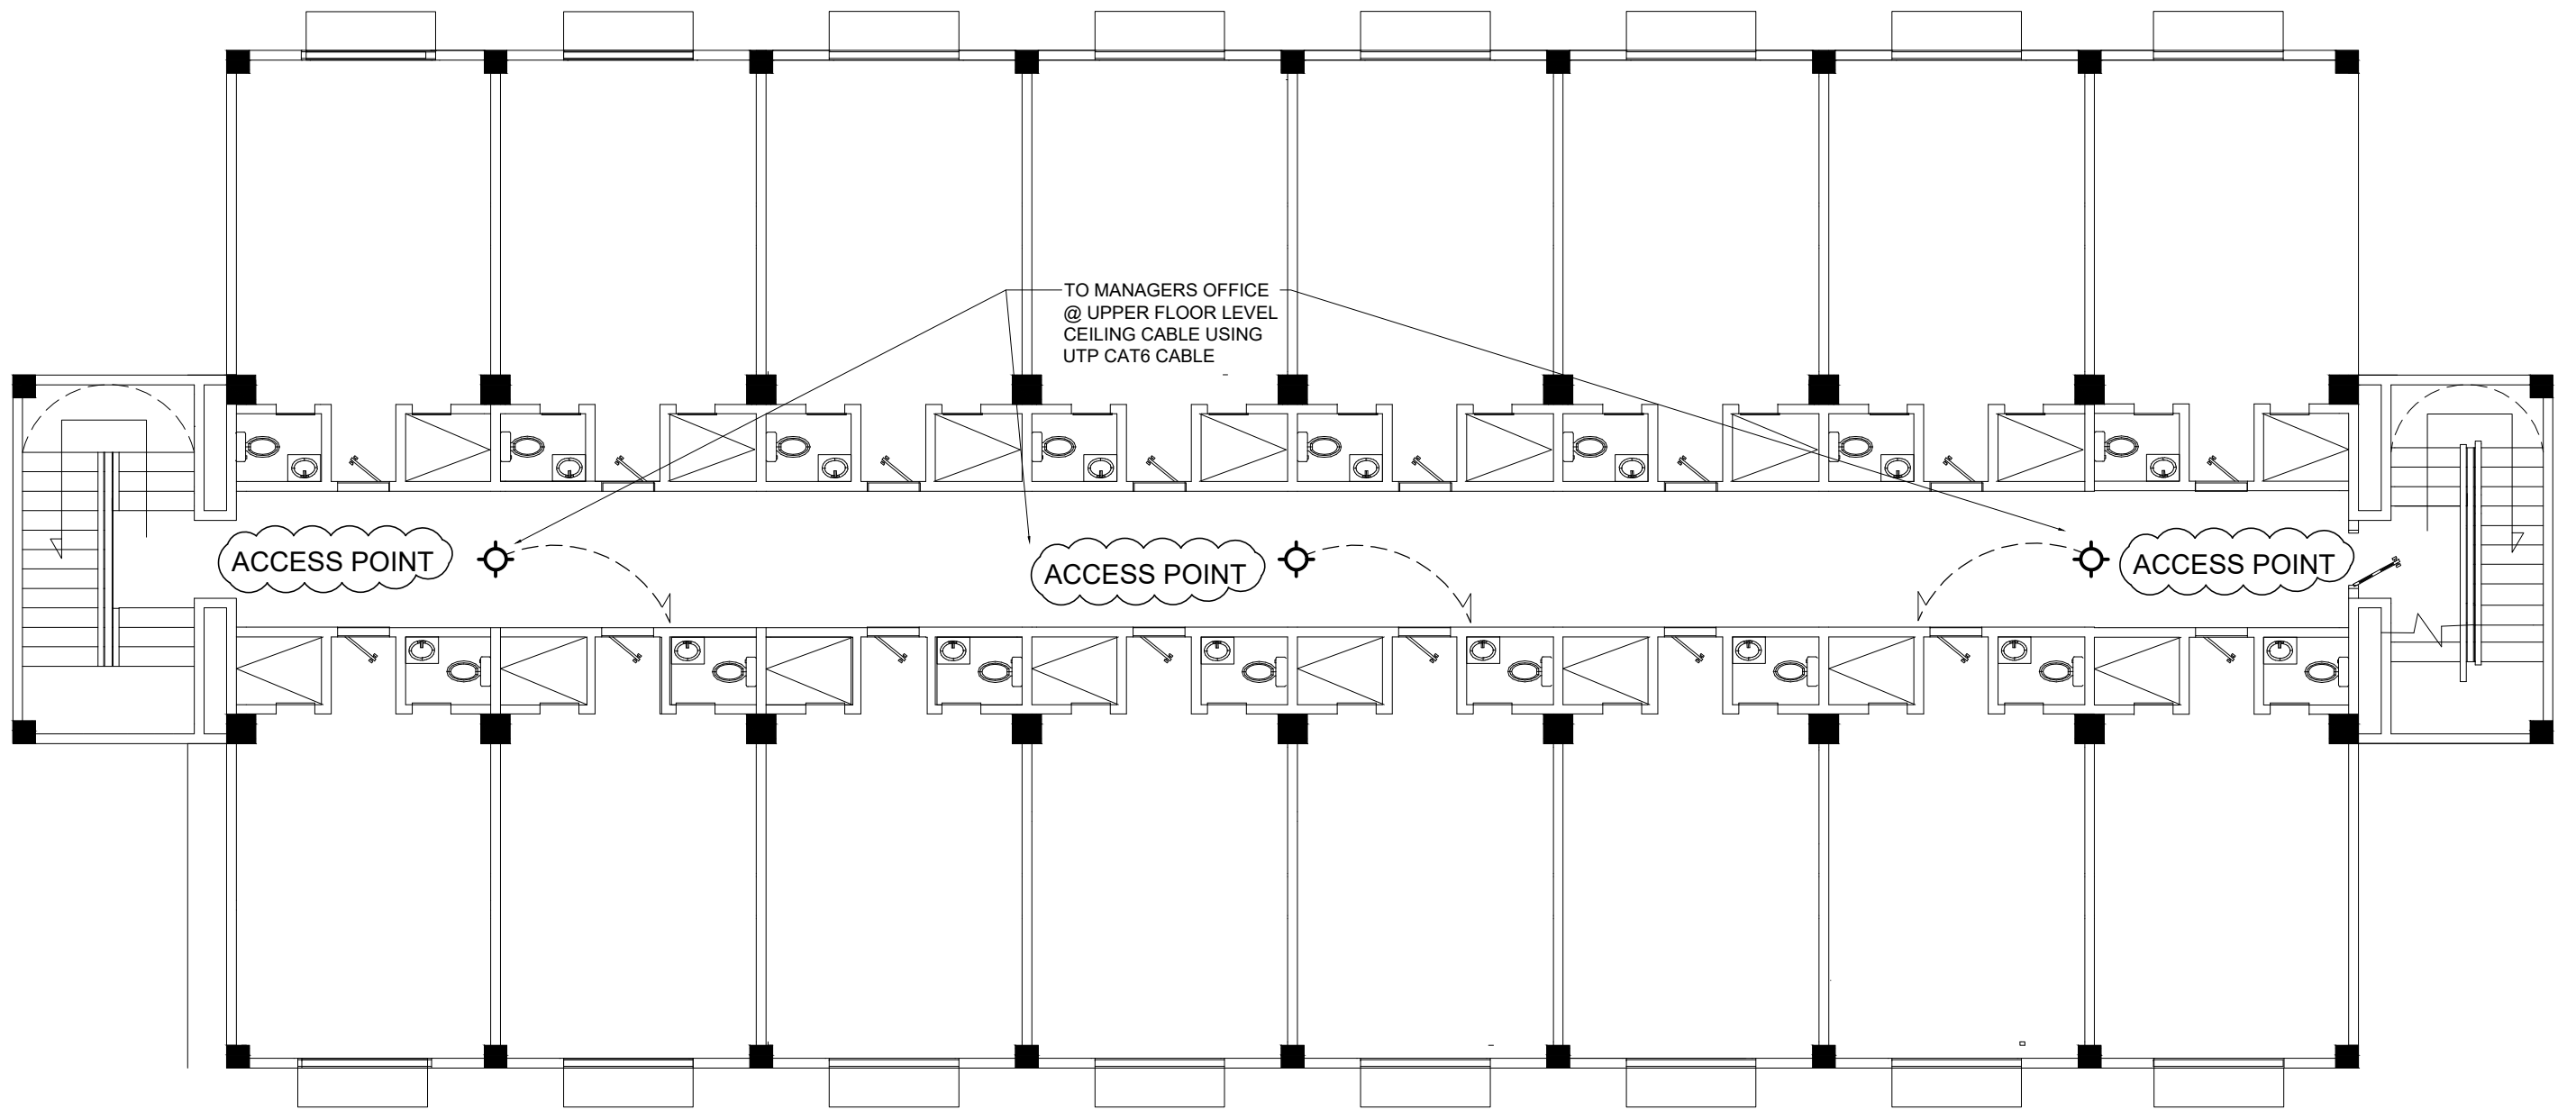


3
EE-6

SECOND FLOOR DATA LAYOUT

SCALE

1:100

M.

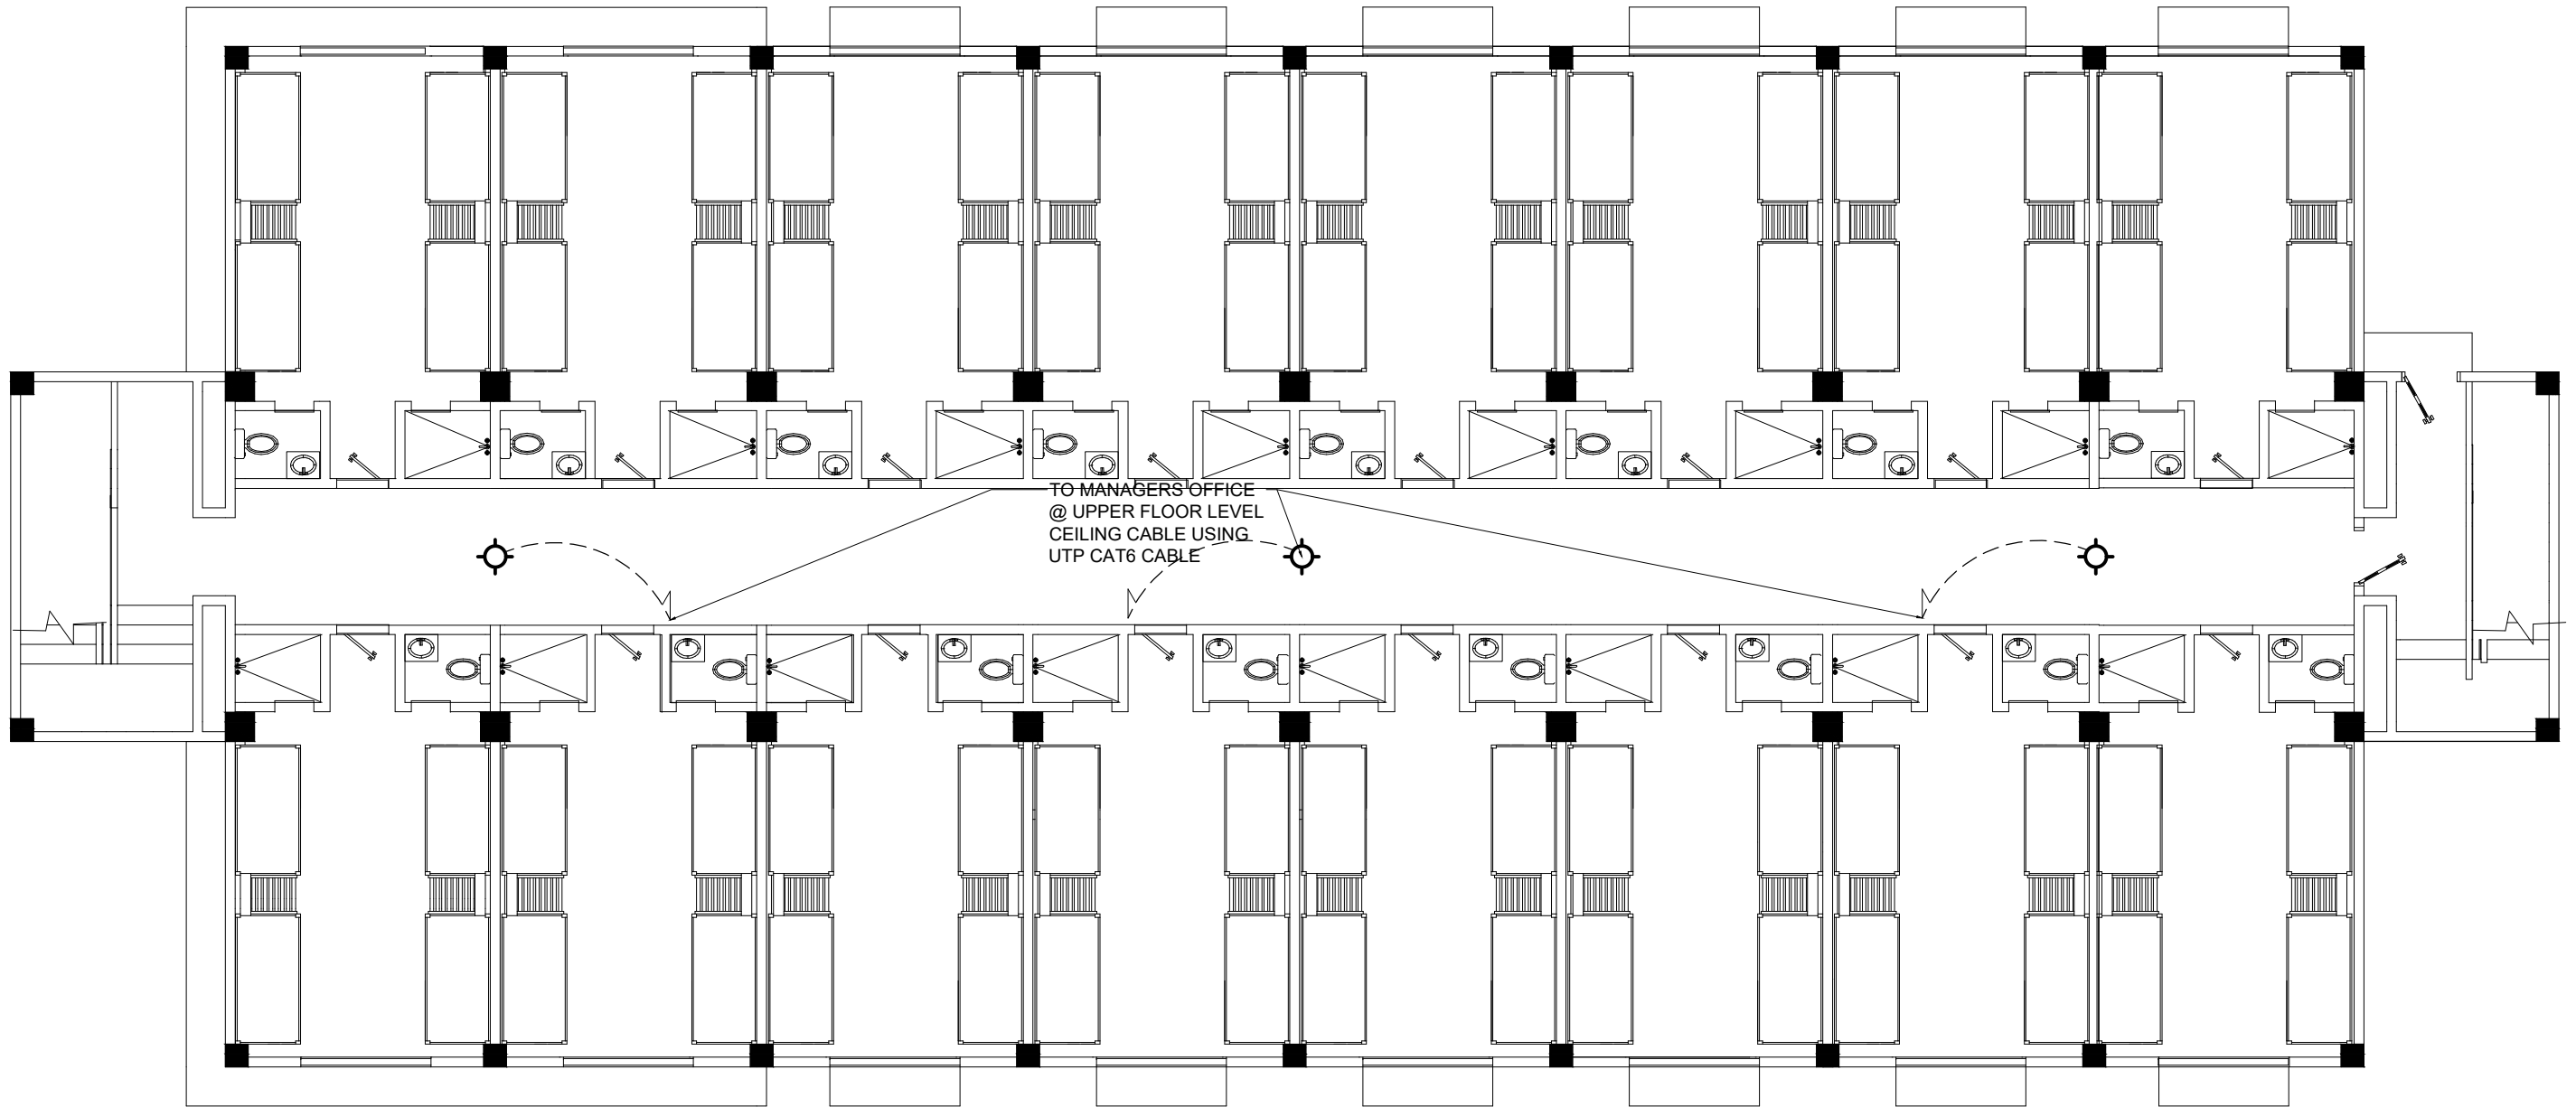

4
EE-6

THIRD FLOOR DATA LAYOUT

SCALE 1:100 M.

DECK SLAB ABOVE STAIR

ACCESS POINT TO CEILING
DATA CABLE @ HALLWAY

UTP CAT 6
CABLE

THIRD FLOOR

ACCESS POINT TO CEILING
DATA CABLE @ HALLWAY

UTP CAT 6
CABLE

SECOND FLOOR

MANAGERS OFFICE

ACCESS POINT TO CEILING
DATA CABLE @ HALLWAY

TO OFFICE, STUDY HALL,
ISOLATION ROOM AND
COMPUTER ROOM



UPPER GROUND FLOOR

MANAGERS OFFICE


ACCESS POINT TO CEILING
DATA CABLE @ HALLWAY

UTP CAT 6
CABLE

LINKED EACH OTHER




LOWER GROUND FLOOR

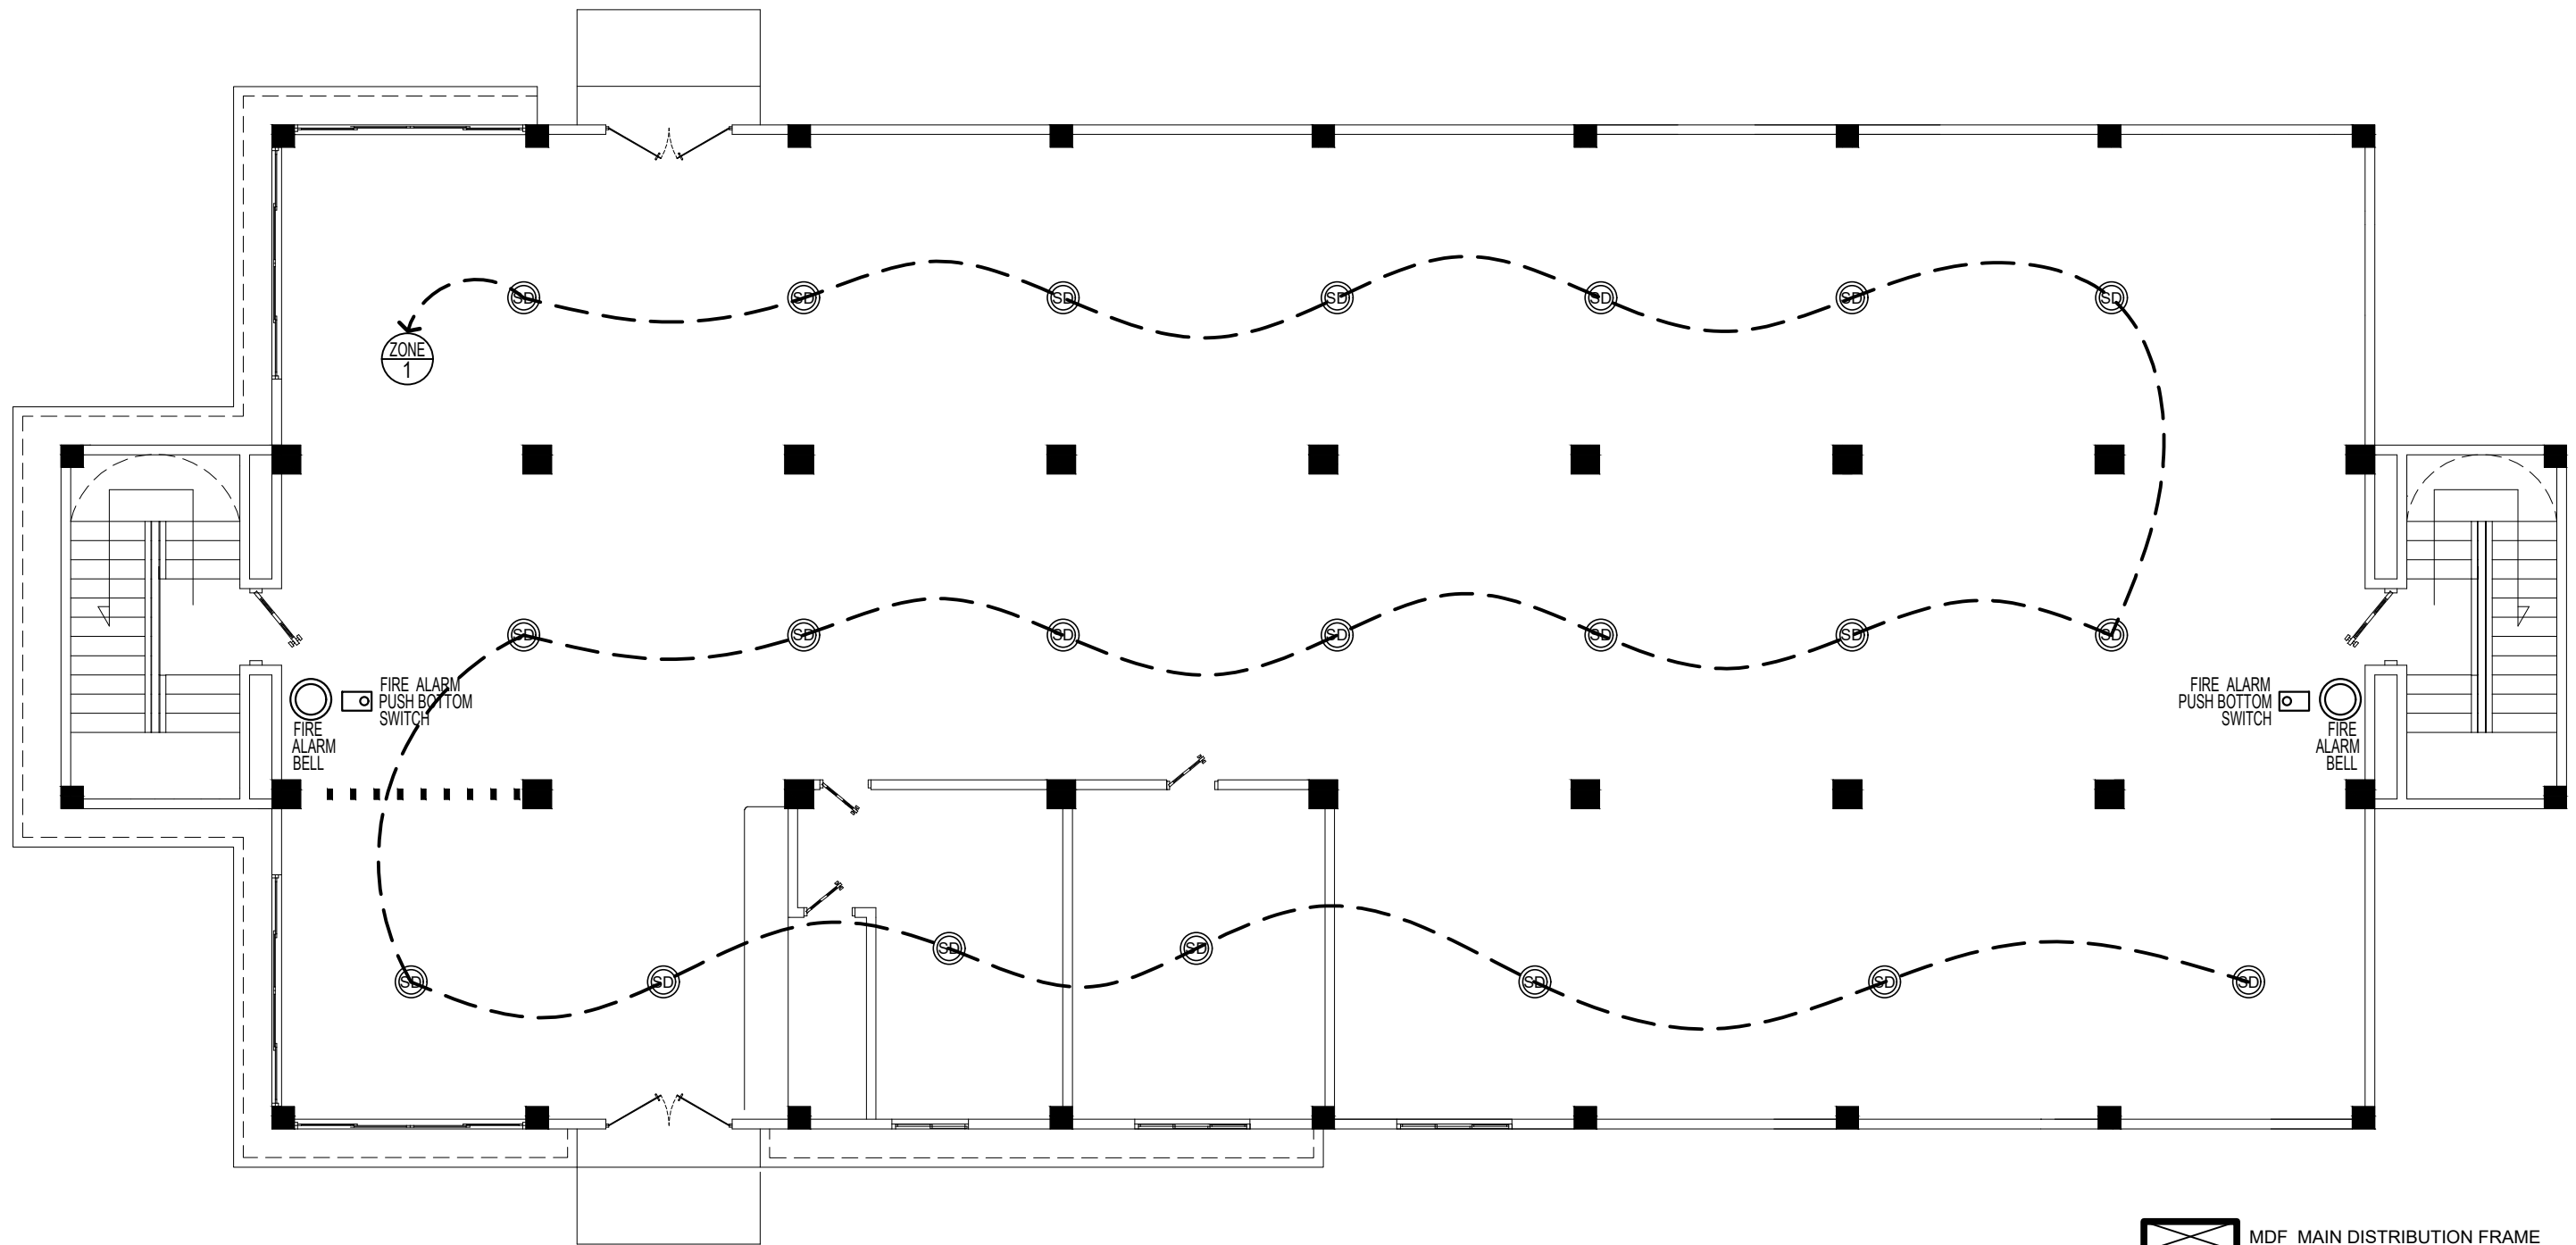

1
LOWER GROUND FLOOR LAYOUT(FDAS)
AUX-5
SCALE
1:100
M.

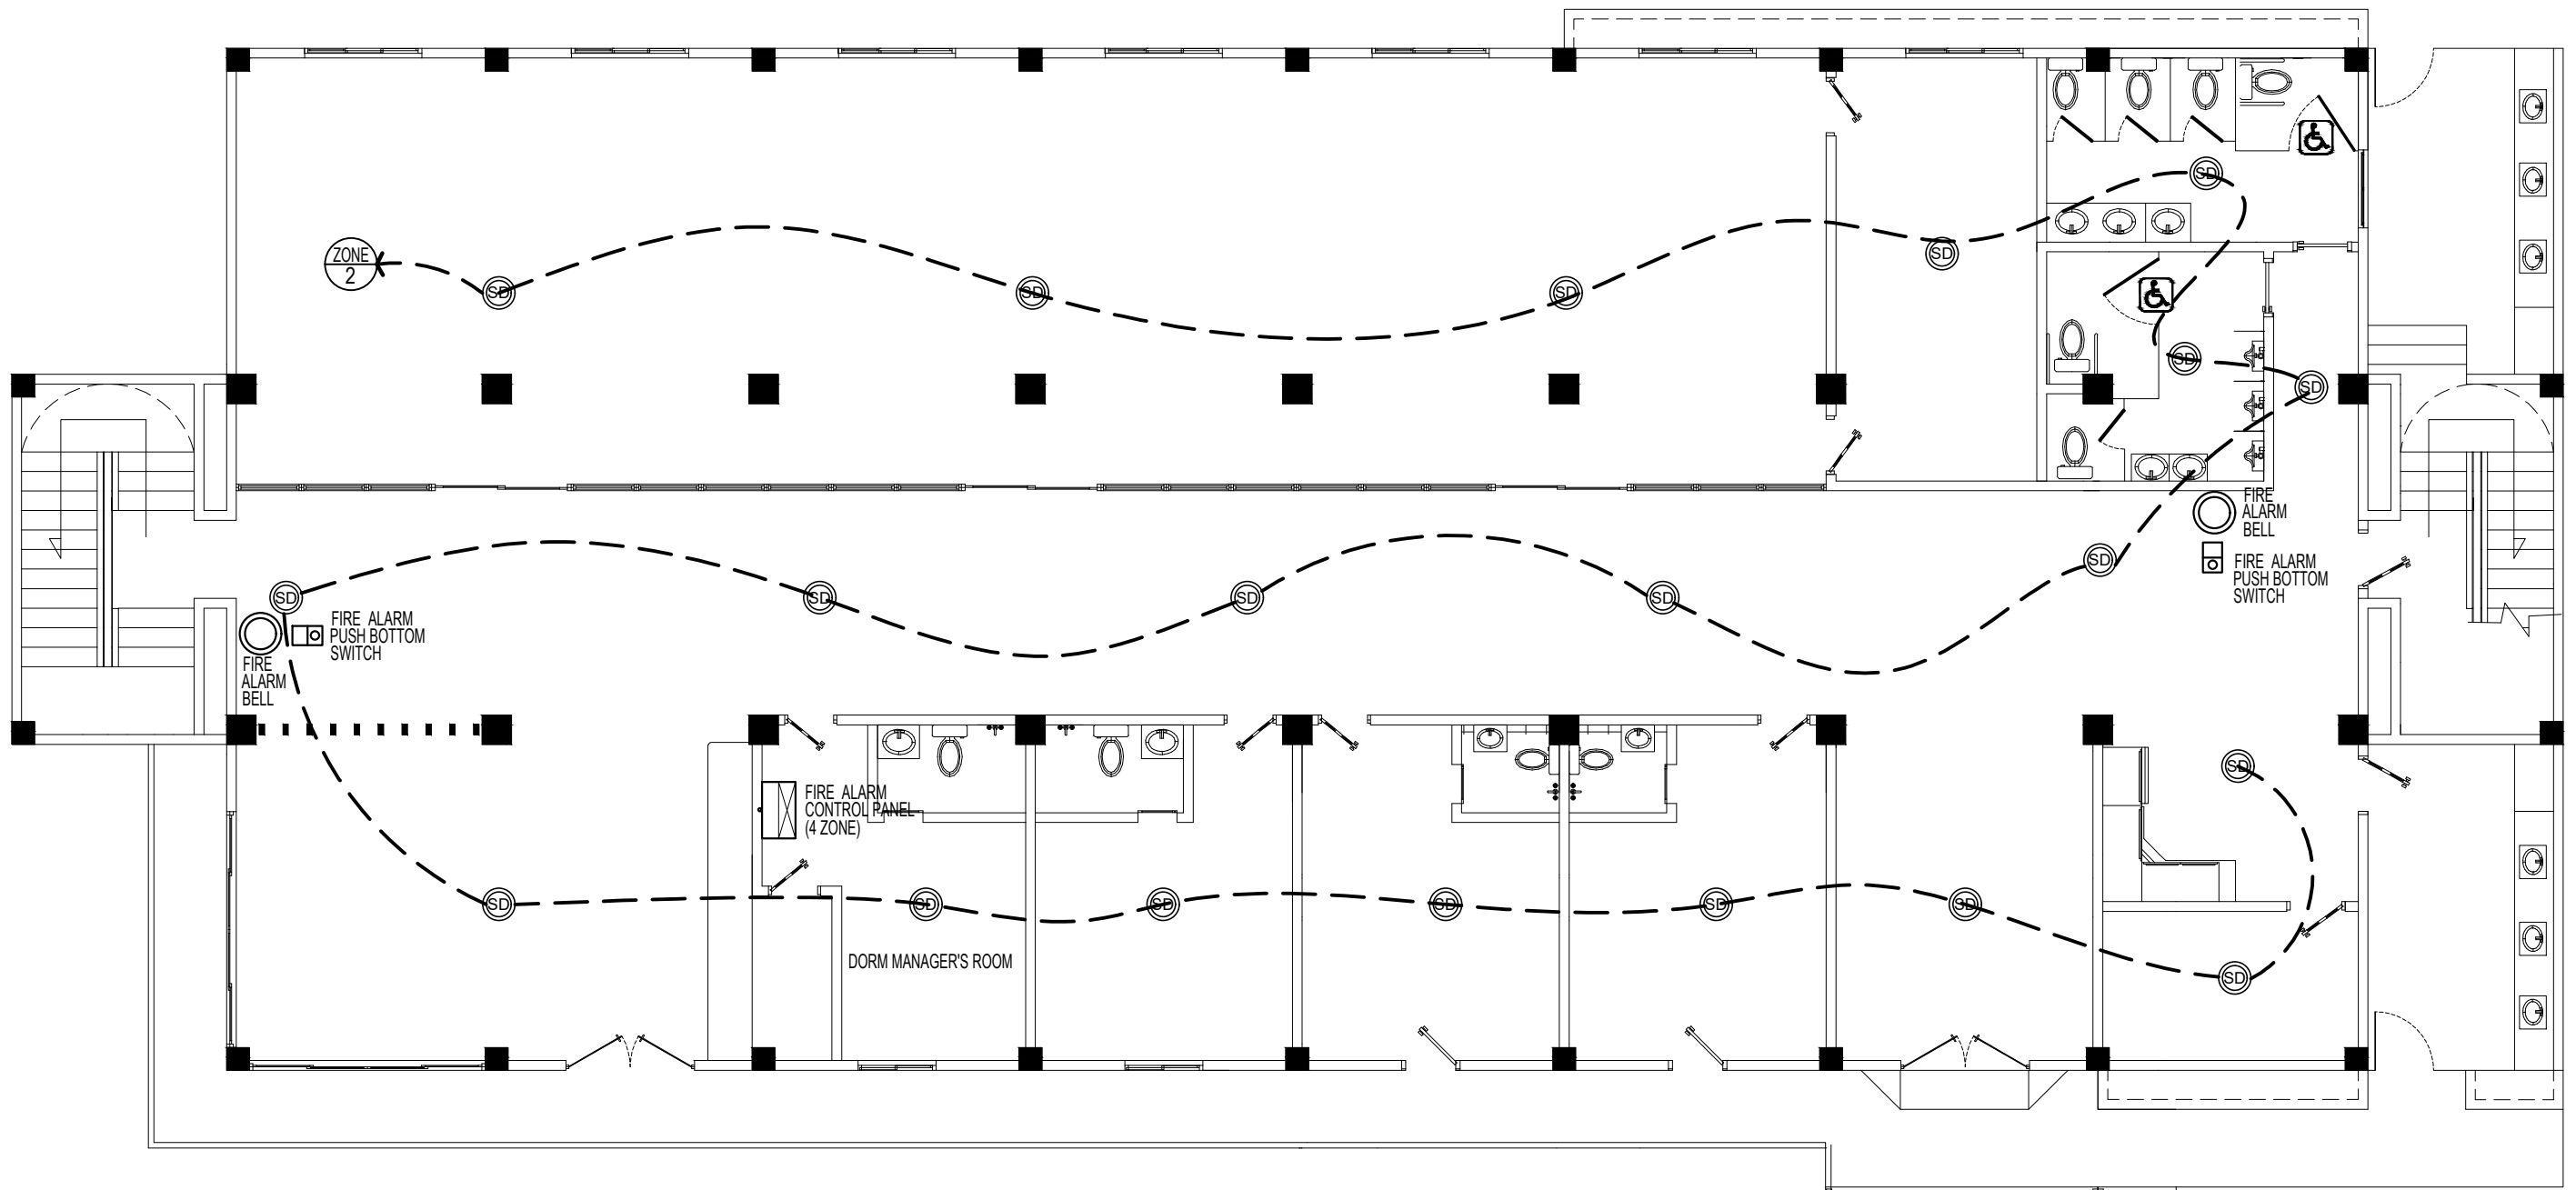


 

 

 



- MDF MAIN DISTRIBUTION FRAME
- DC DATA CABINET
- D.O DUPLEX OUTLET
- RT ROUTER
- PR PRINTER
- PC PERSONAL COMPUTER
- MD MODEM
- TV TELEVISION
- ACCESS POINT
- UTP CAT6 CABLE
- CONVENTIONAL SMOKE DETECTOR




2
AUX-5

UPPER GROUND FLOOR LAYOUT (FDAS SYSTEM INSTALLATION)

SCALE 1:100 M.



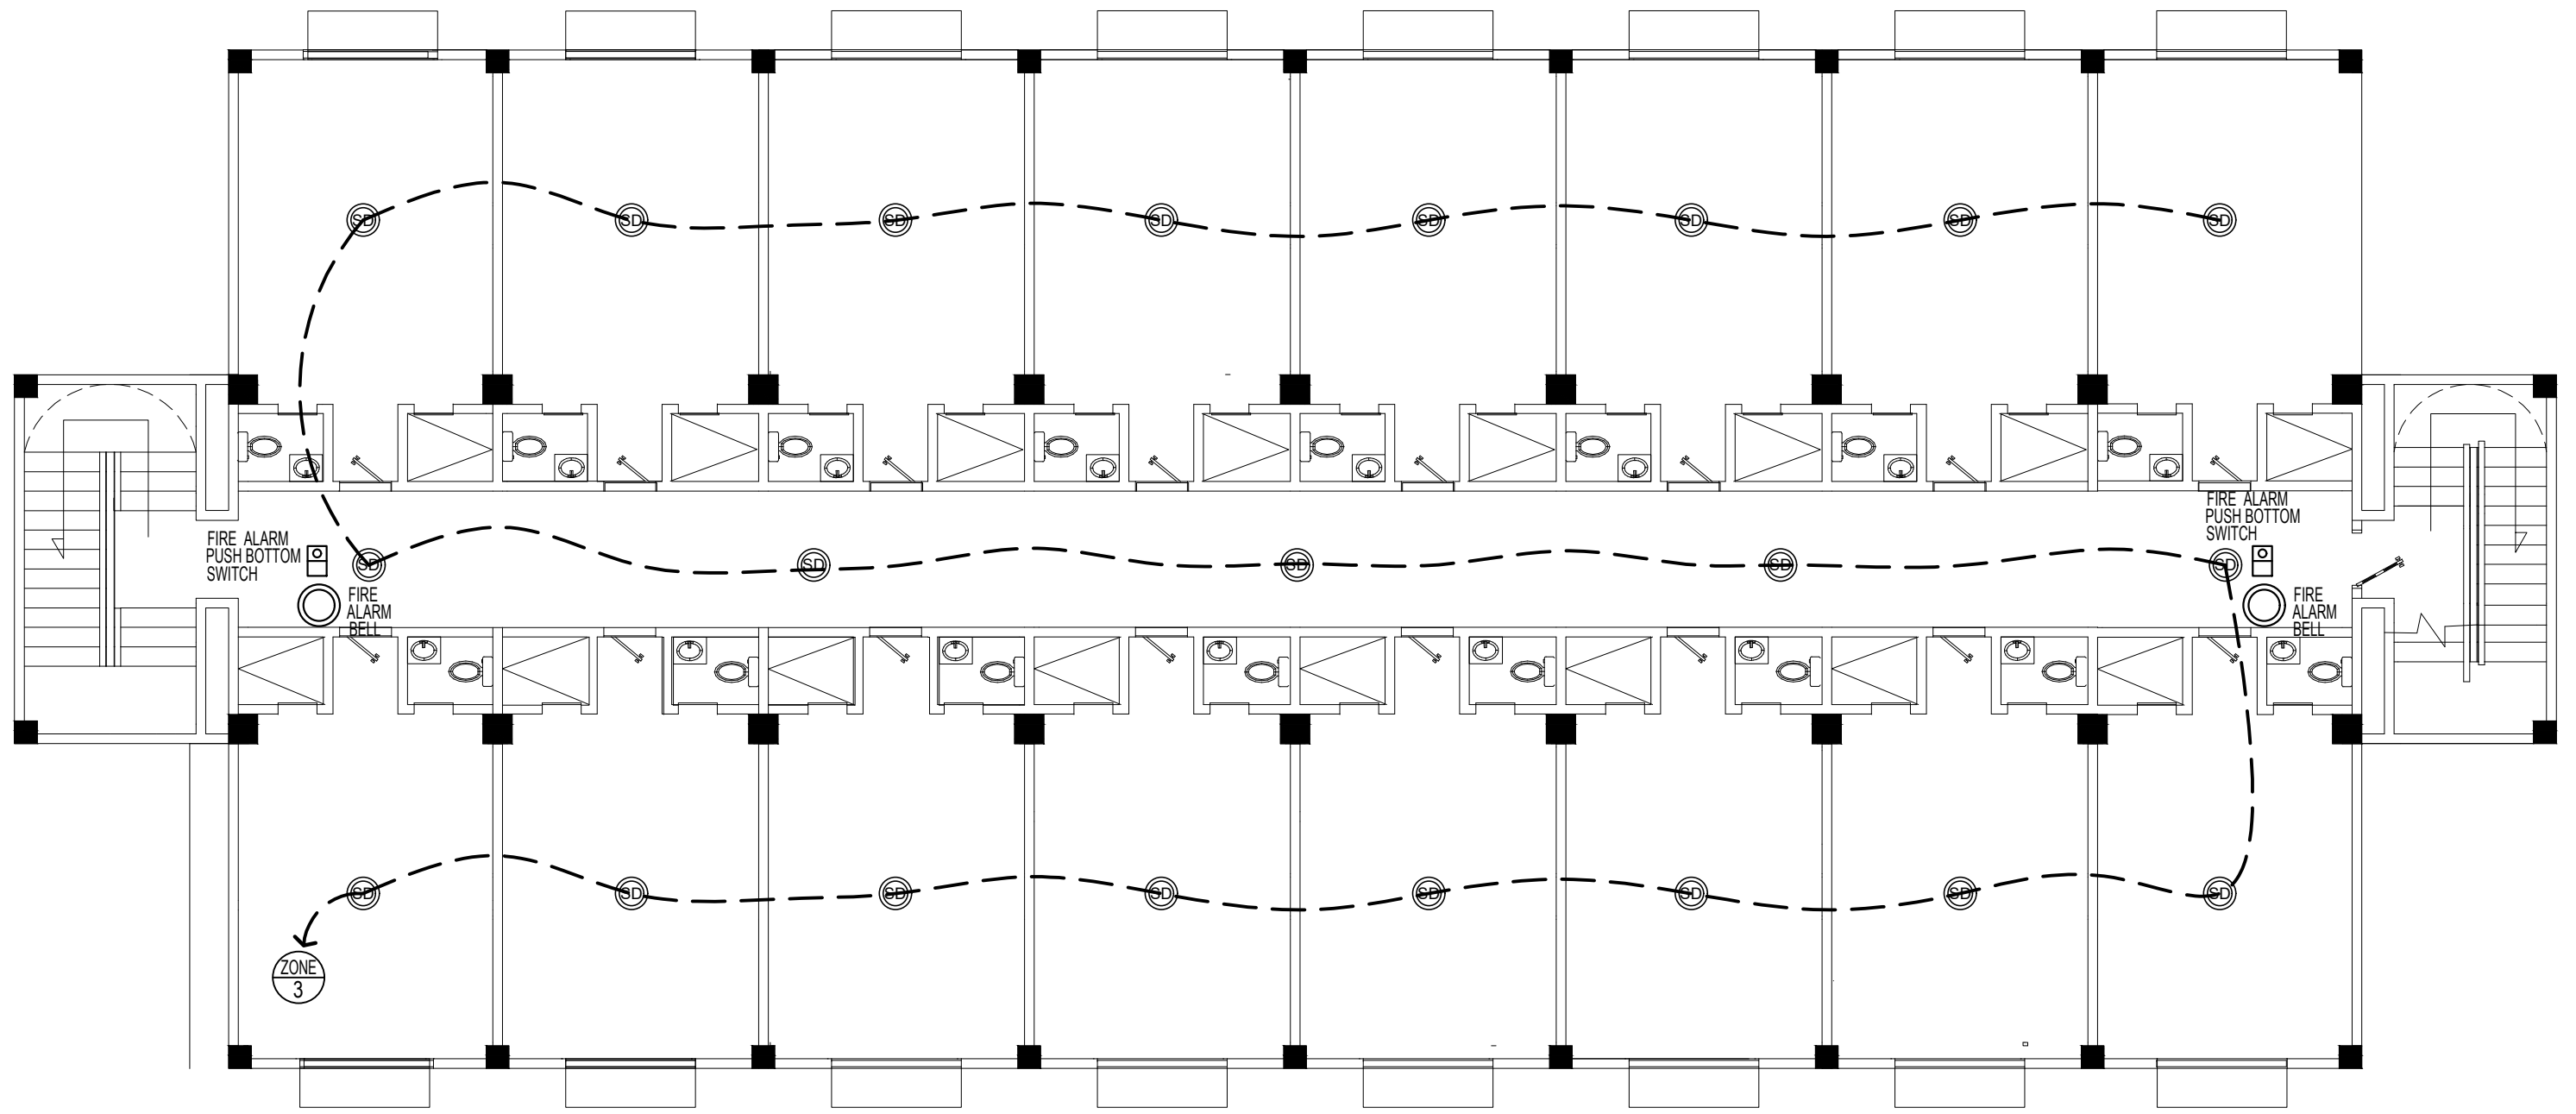



 

 
 
 
-  MDF MAIN DISTRIBUTION FRAME
-  DC DATA CABINET
-  D.O DUPLEX OUTLET
-  RT ROUTER
-  PR PRINTER
-  PC PERSONAL COMPUTER
-  MD MODEM
-  TV TELEVISION
-  ACCESS POINT
-  UTP CAT6 CABLE
-  CONVENTIONAL SMOKE DETECTOR




1
AUX-6

SECOND FLOOR LAYOUT(FDAS SYSTEM INSTALLATION)


SCALE 1:100 M.

-  MDF MAIN DISTRIBUTION FRAME
-  DC DATA CABINET
-  D.O DUPLEX OUTLET
-  RT ROUTER
-  PR PRINTER
-  PC PERSONAL COMPUTER
-  MD MODEM
-  TV TELEVISION
-  ACCESS POINT
-  UTP CAT6 CABLE
-  CONVENTIONAL SMOKE DETECTOR

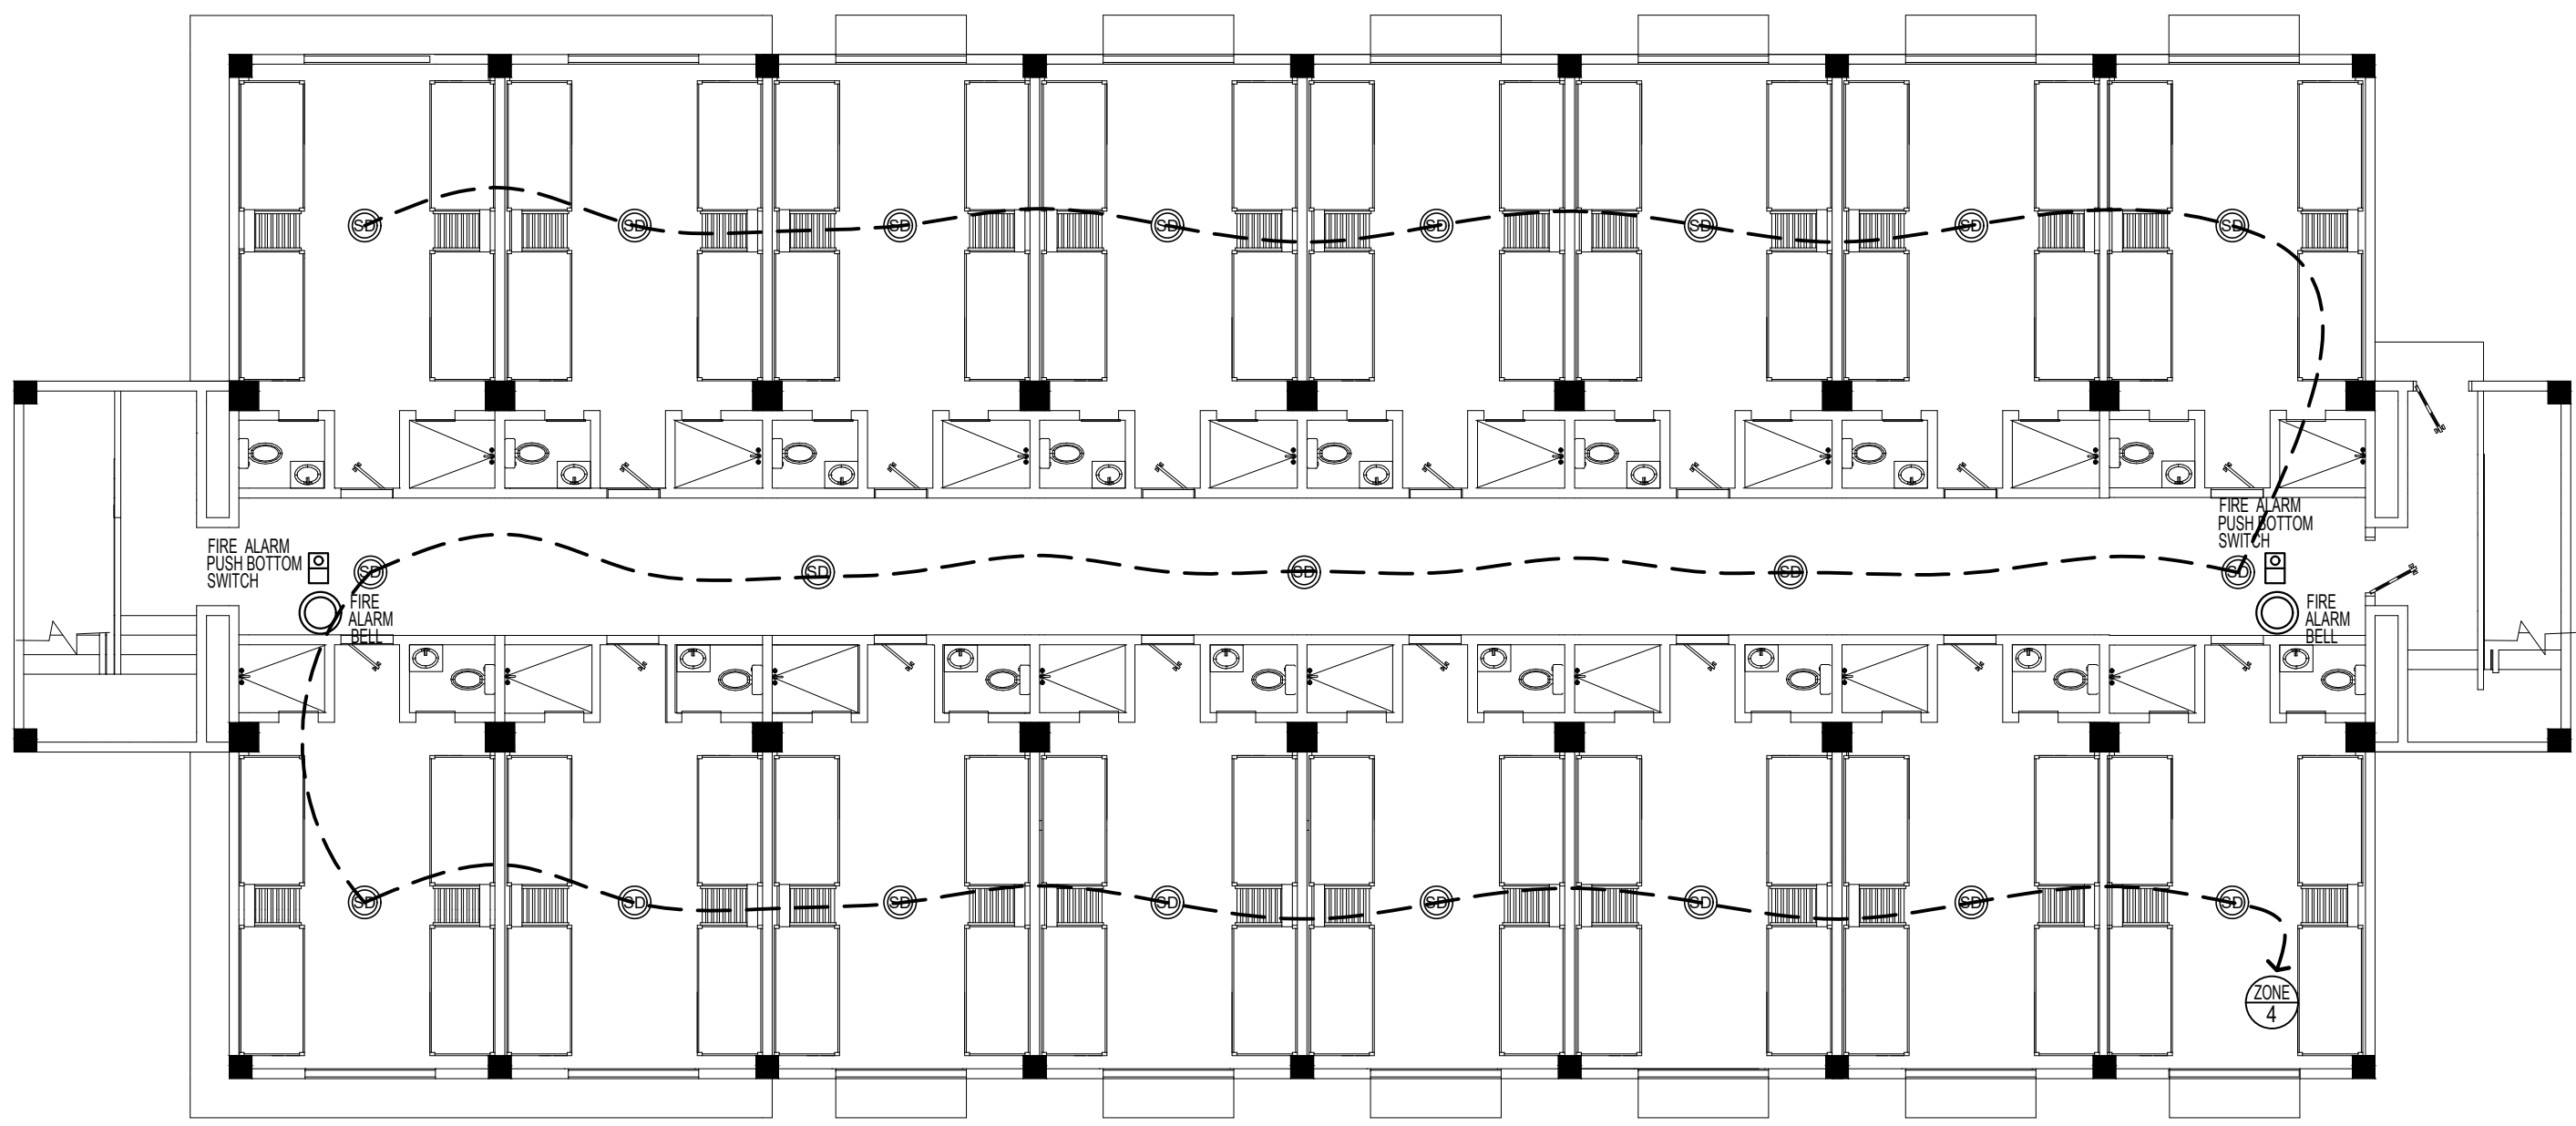

2
AUX-6
THIRD FLOOR LAYOUT(FDAS)
 SCALE 1:100 M.

- MDF MAIN DISTRIBUTION FRAME
- DC DATA CABINET
- D.O DUPLEX OUTLET
- RT ROUTER
- PR PRINTER
- PC PERSONAL COMPUTER
- MD MODEM
- TV TELEVISION
- ACCESS POINT
- UTP CAT6 CABLE
- CONVENTIONAL SMOKE DETECTOR

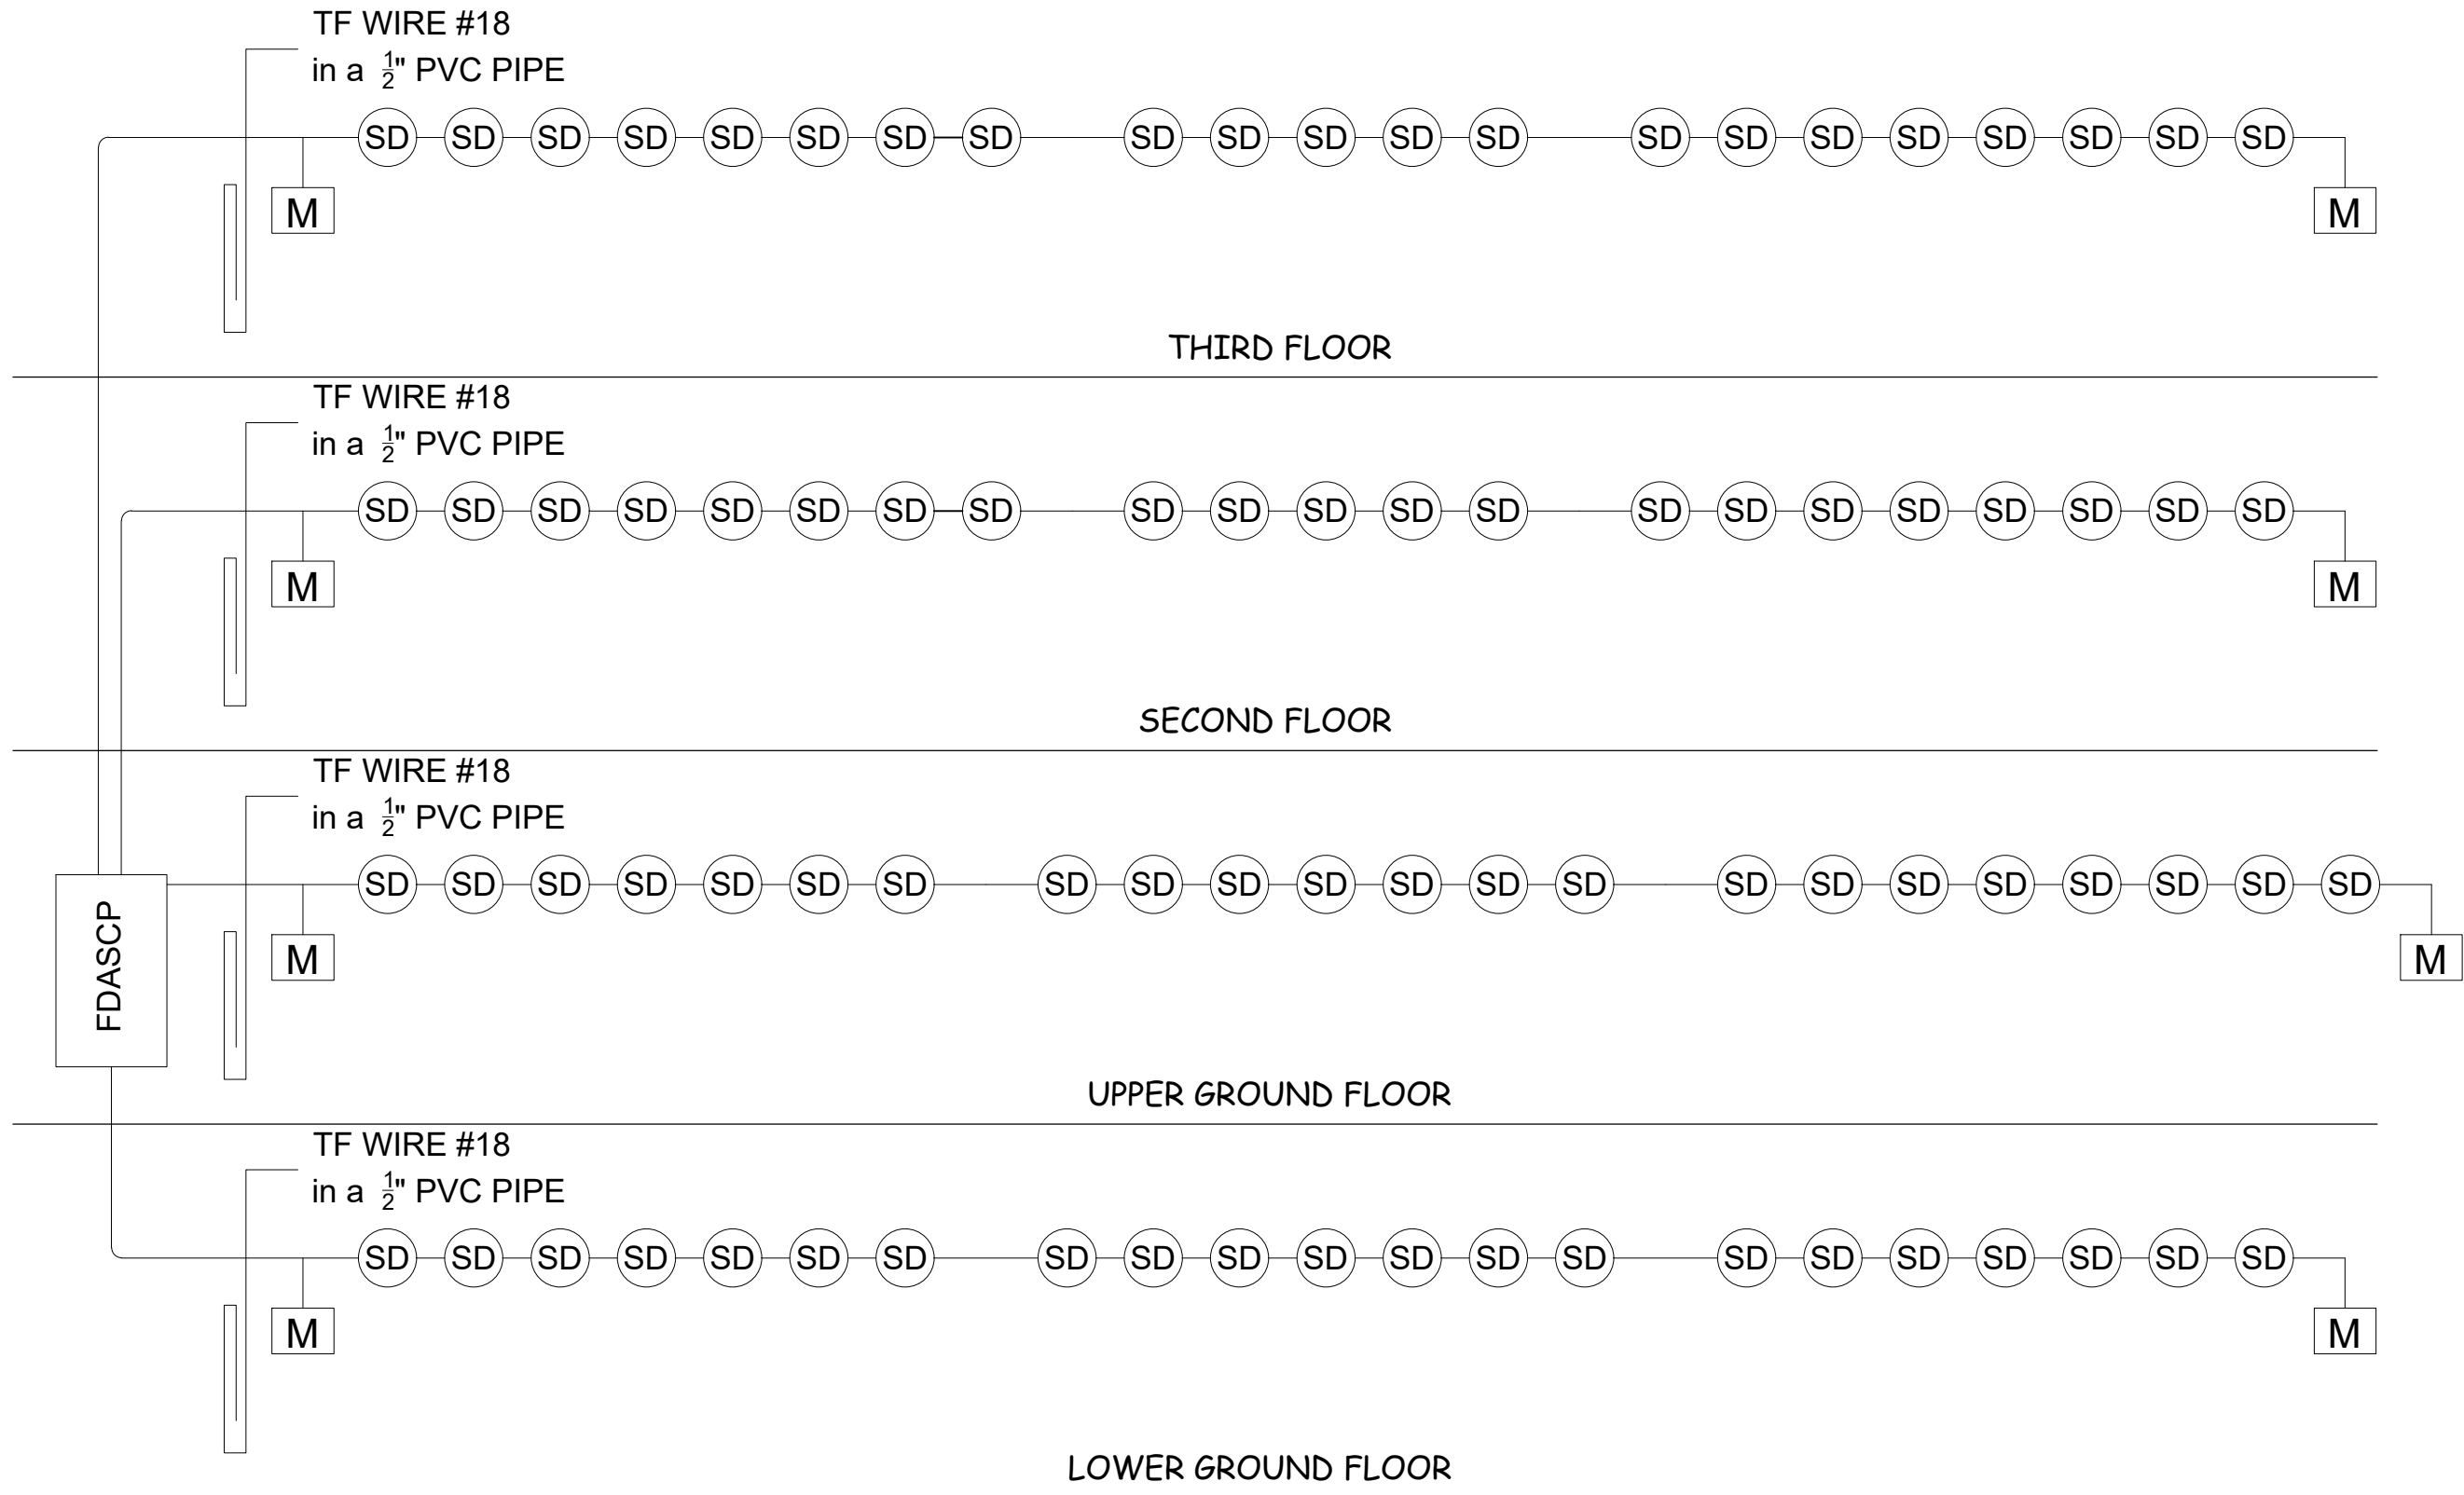

3
(FDAS) SINGLE LINE DIAGRAM
AUX-5
SCALE
NDTS